


EXISTING FLOORPLAN

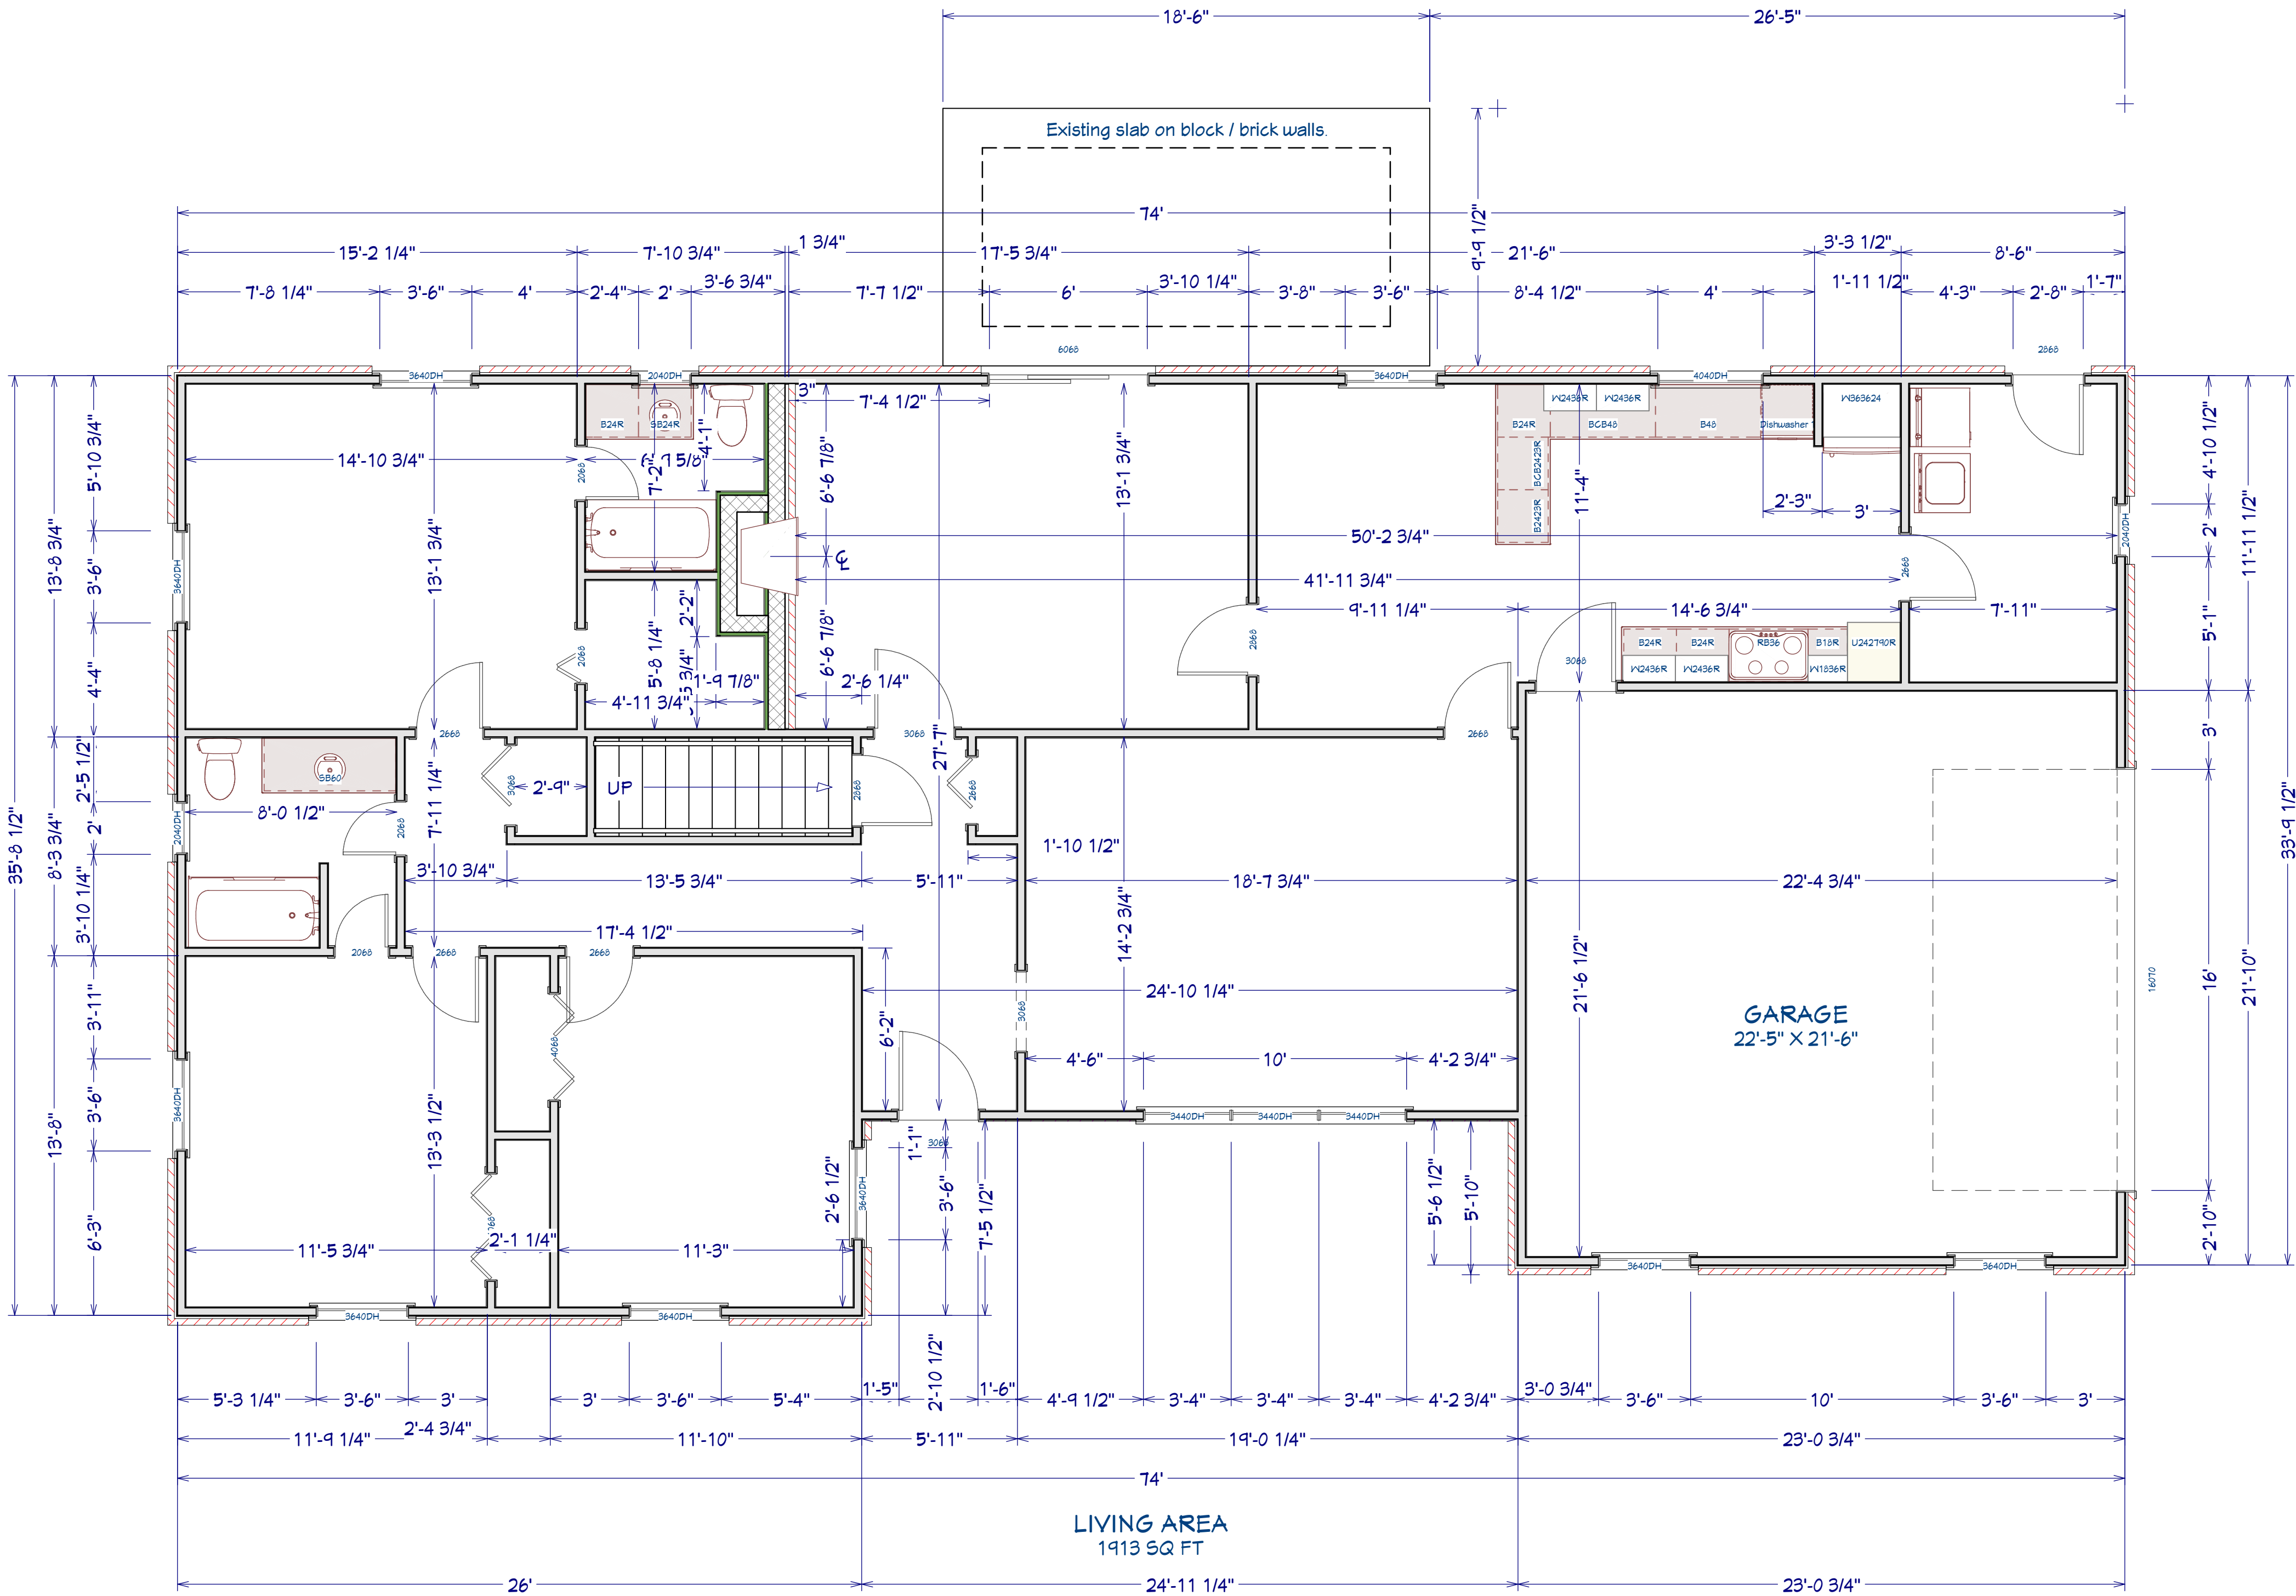

REVISION TABLE		DESCRIPTION
NUMBER	DATE	REVISION BY

703 Eagles Nest Road
Waynesville, NC 28786

DRAWINGS PROVIDED BY:
Dean & Cheryl
Chouinard

DATE:

8/24/20

SCALE:


1/4" = 1'

SHEET:

1

DEMO AREA - REMOVE CEILINGS, INTERIOR WALLS & PANELLING, ETC.

ALL AREAS - REMOVE CABINETS, PLUMBING FIXTURES, LIGHT FIXTURES, FLOORING, DOORS, TRIM, HARDWARE, WINDOWS, ETC.

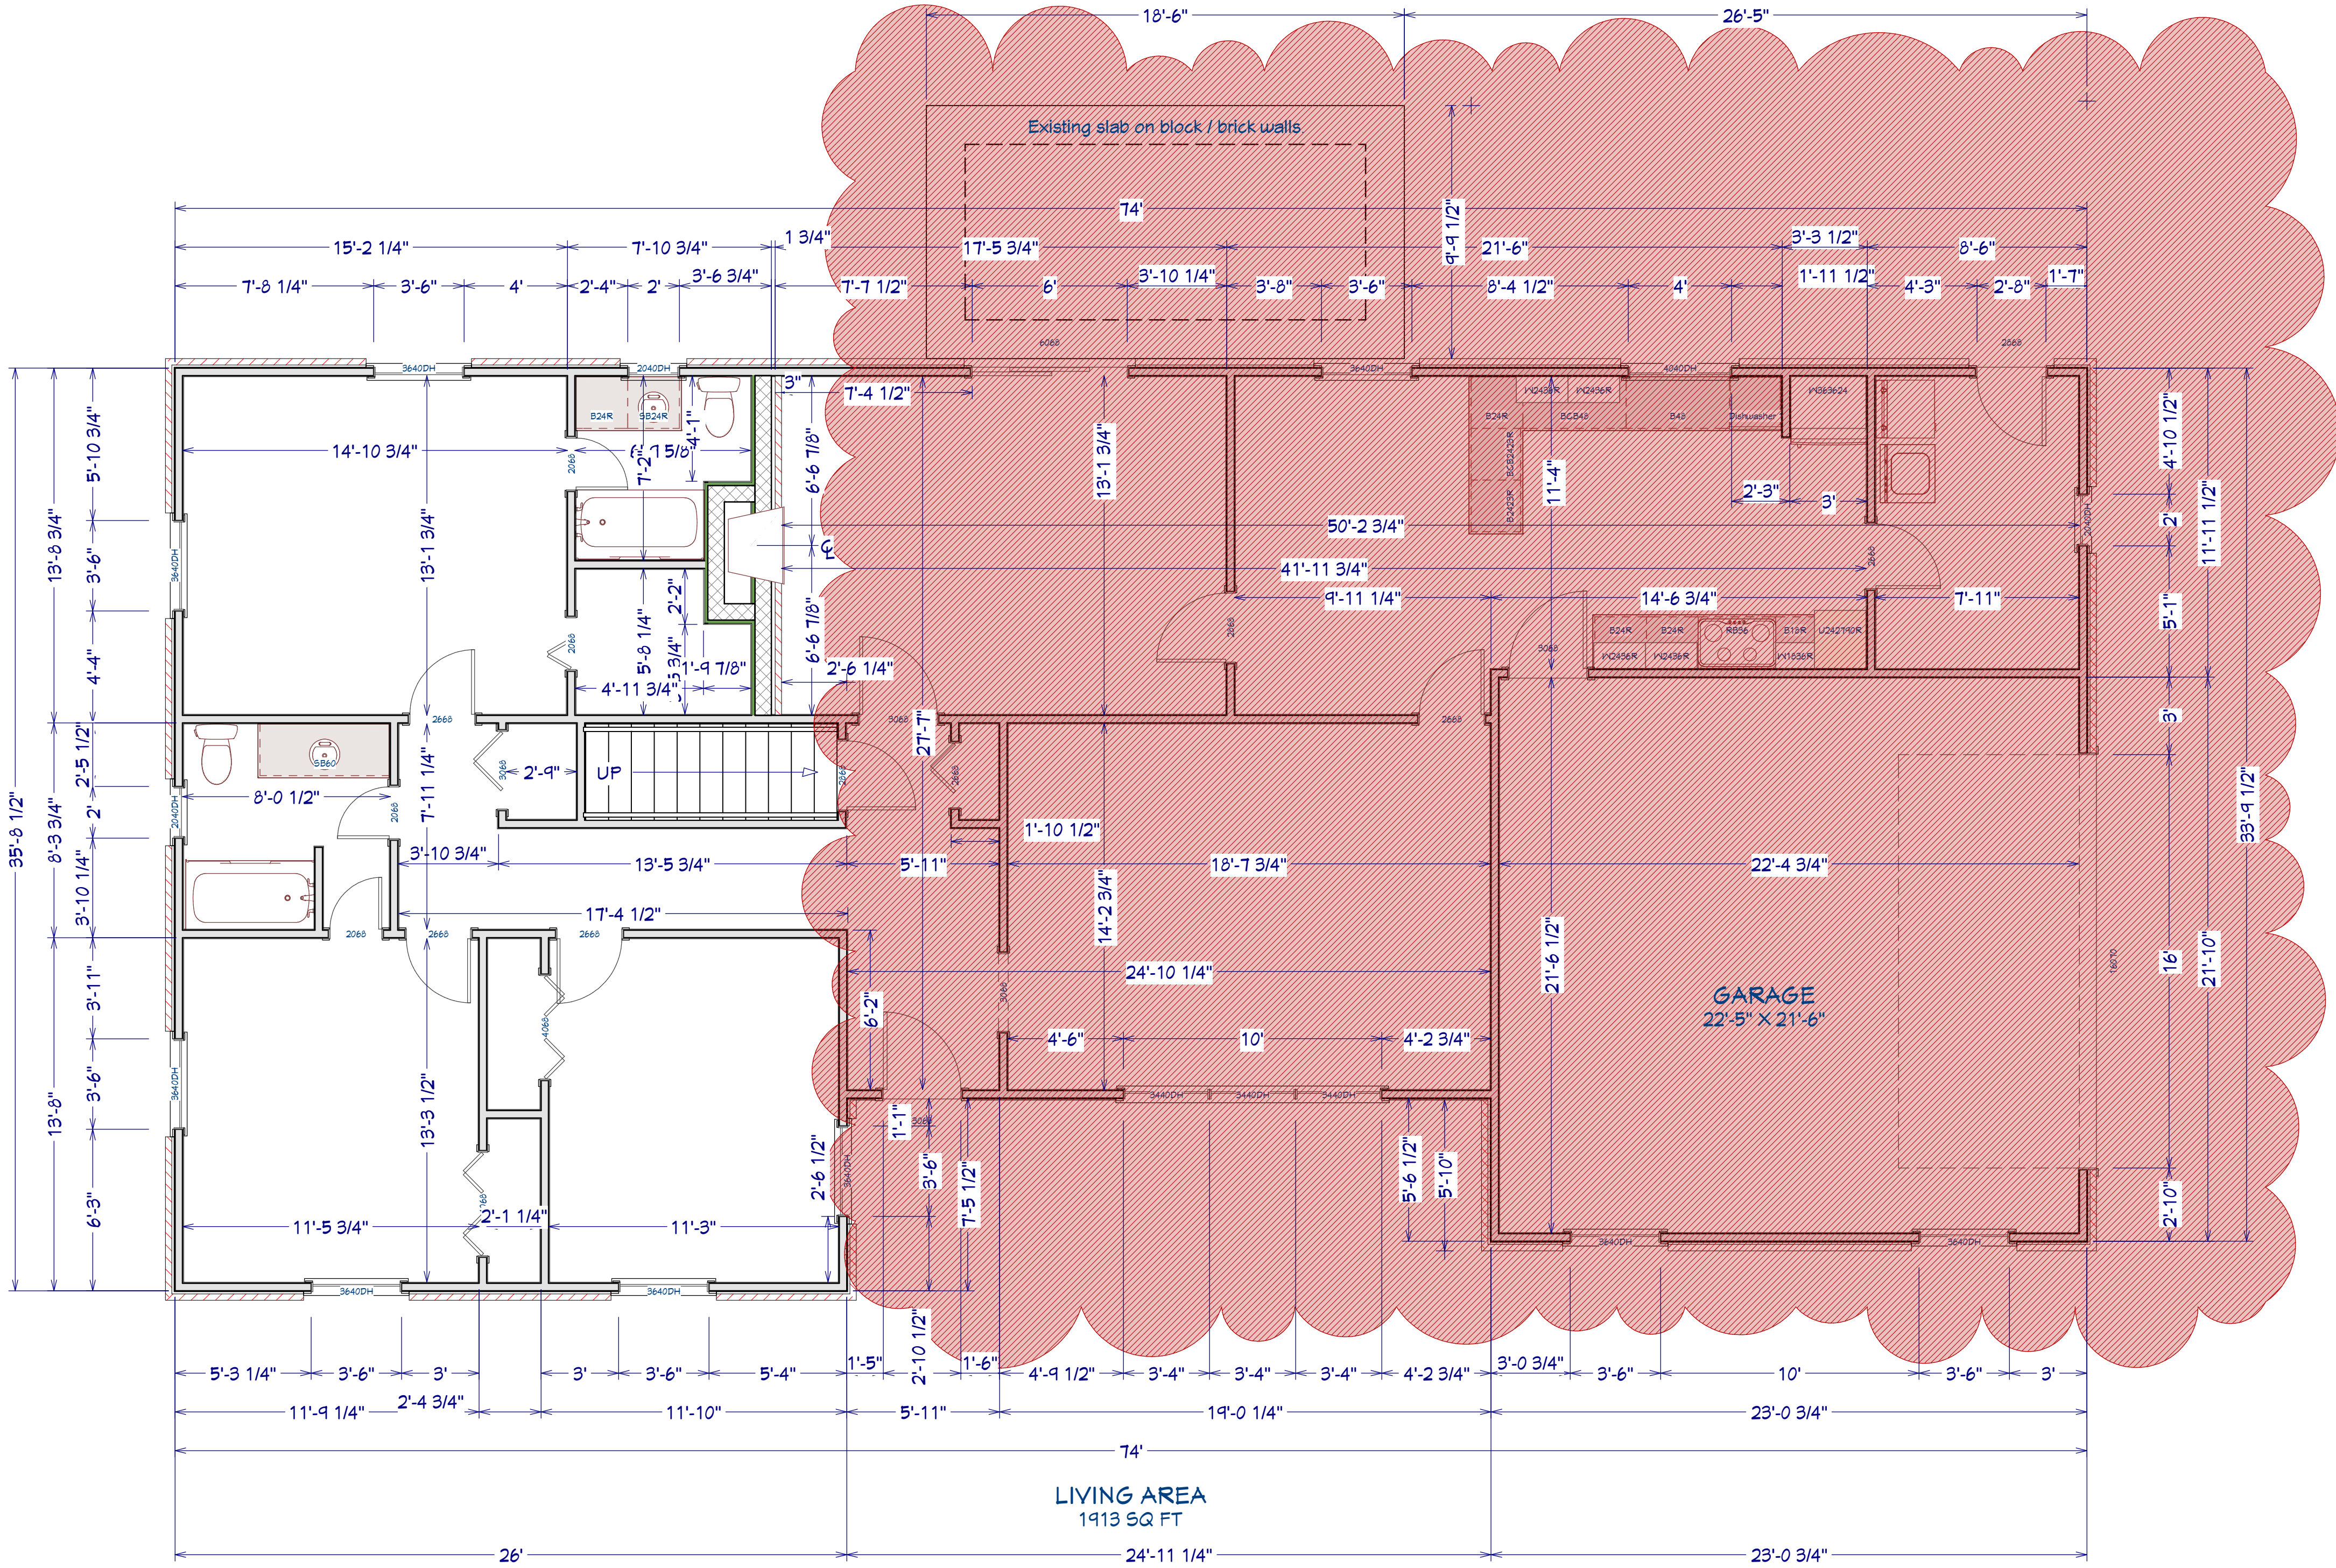

EXISTING HOUSE / DEMO AREA

REVISION TABLE	
NUMBER	DATE

703 Eagles Nest Road
Waynesville, NC 28786

DRAWINGS PROVIDED BY:
Dean & Cheryl
Chouinard

DATE:

8/24/20


SCALE:

1/4" = 1'

SHEET:

2

EXISITNG / NEW FOUNDATION

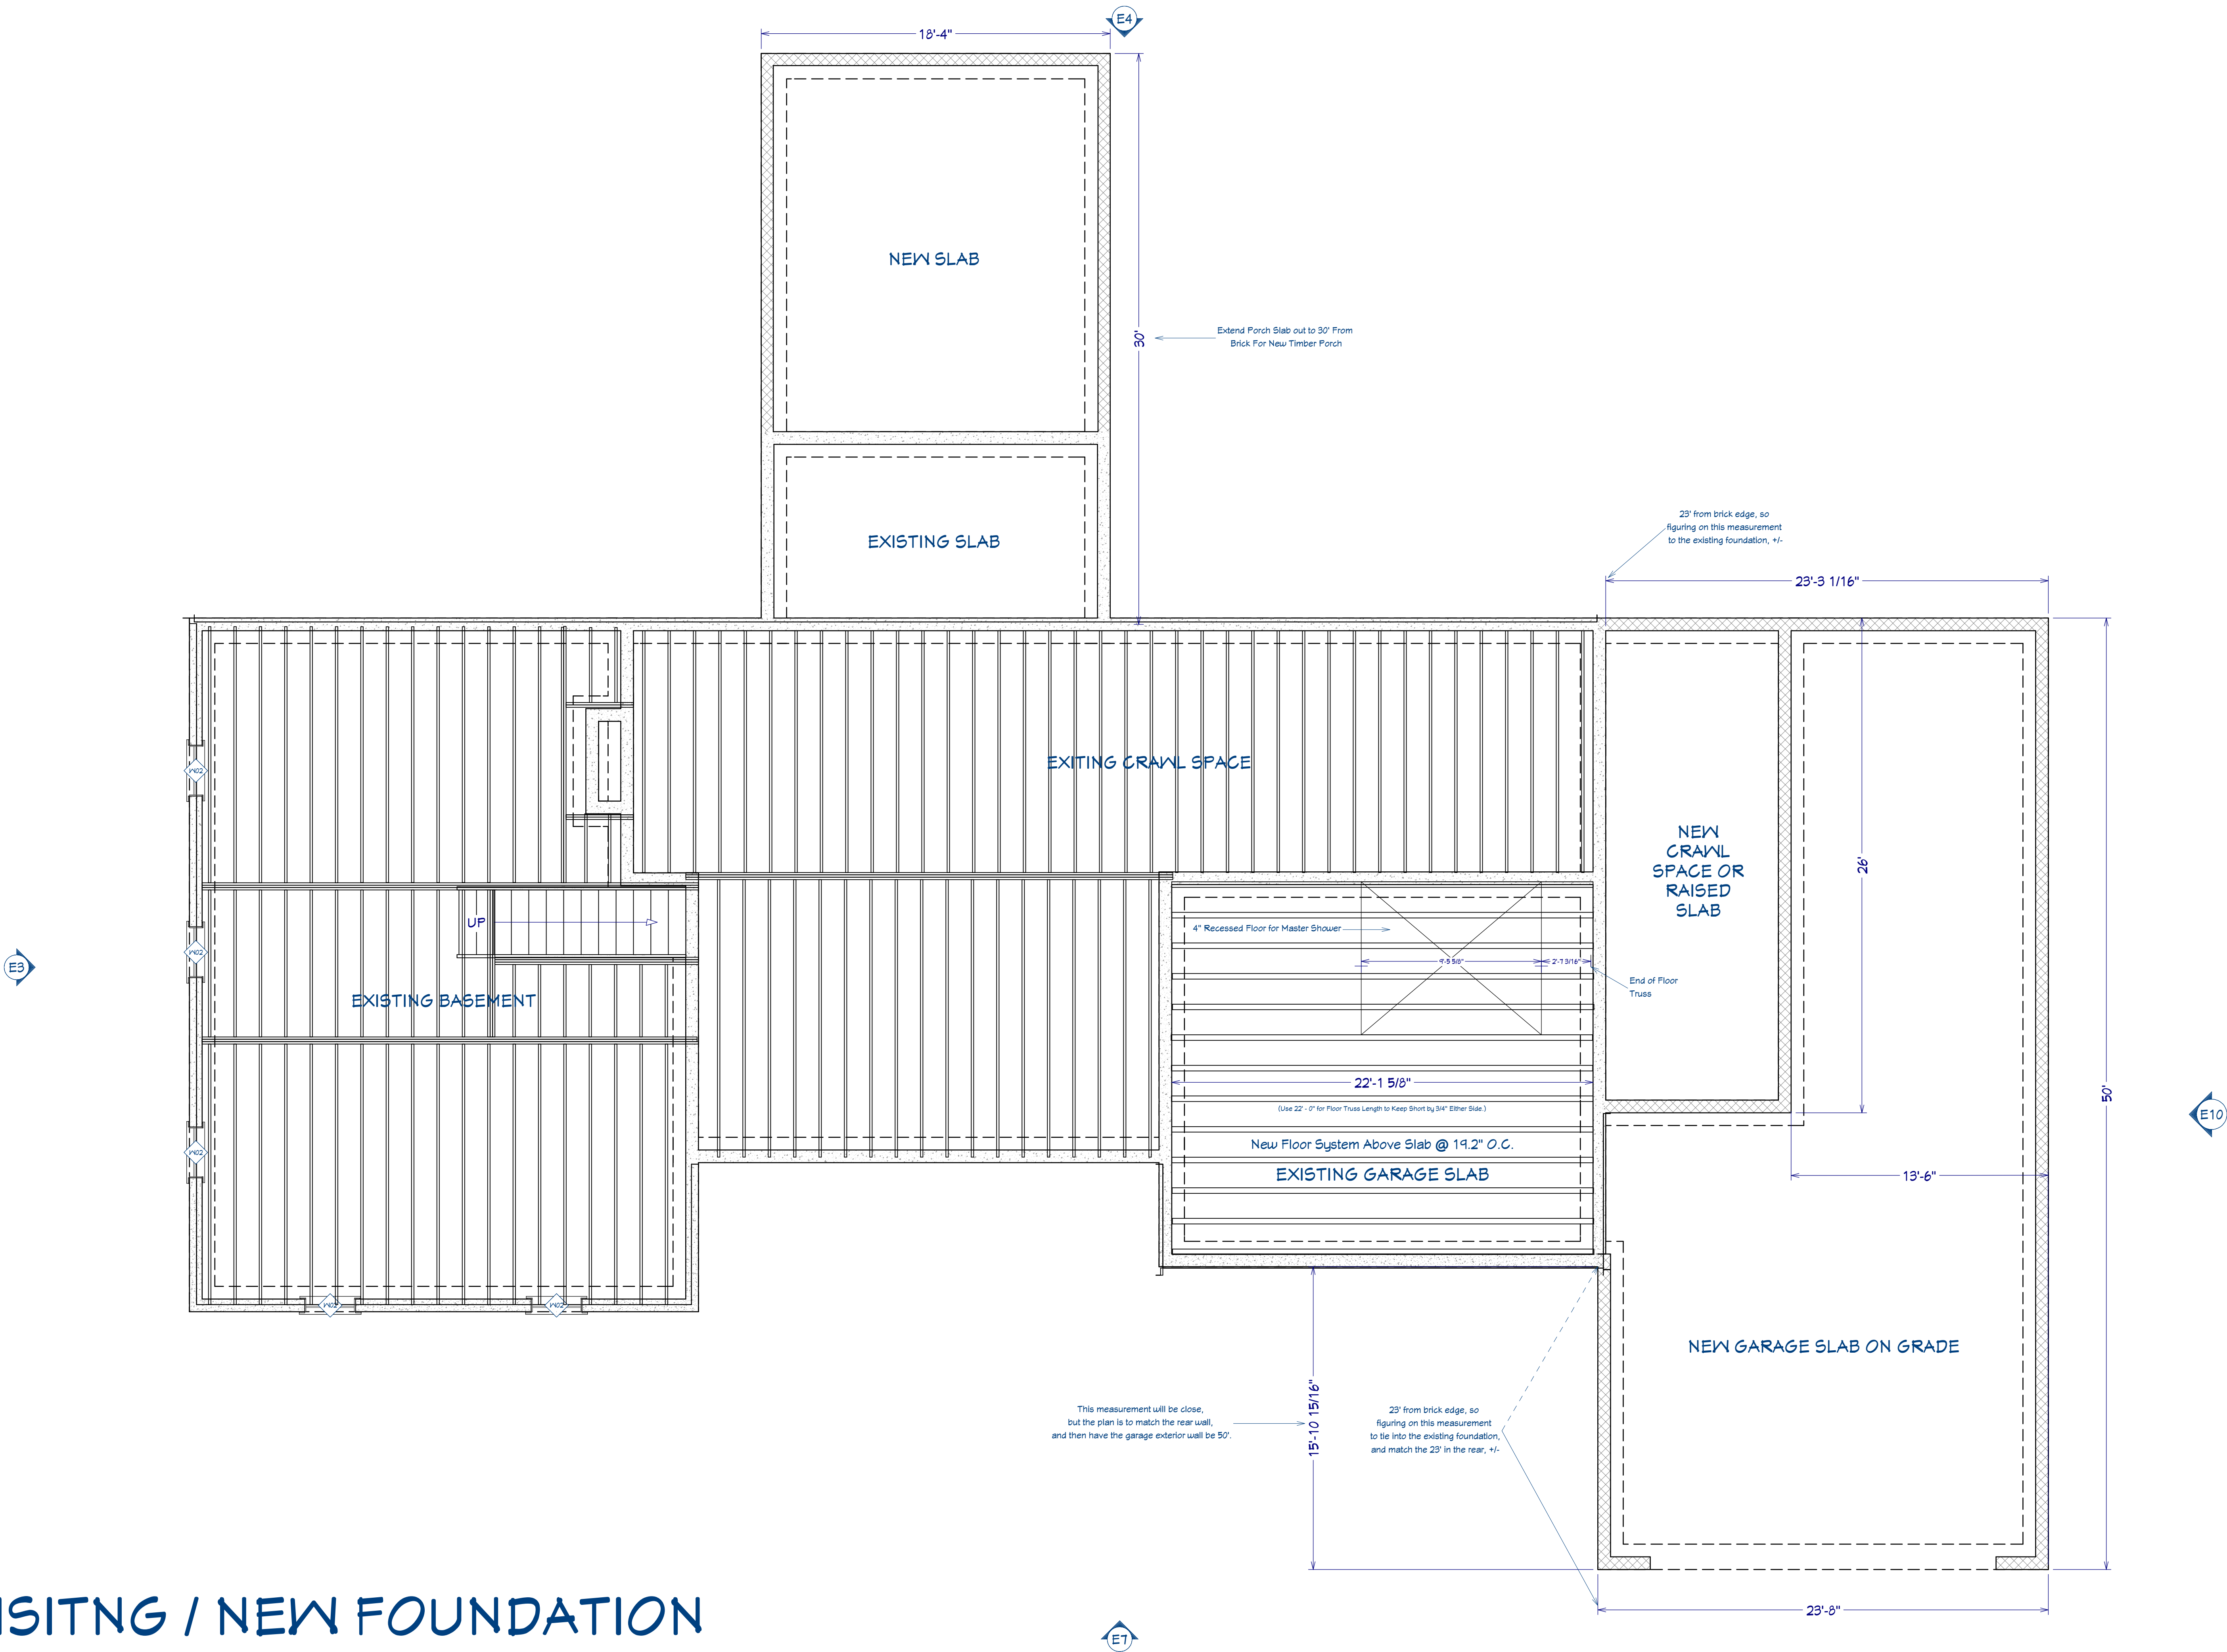

REVISION TABLE	
NUMBER	DATE

703 Eagles Nest Road
Waynesville, NC 28786


DRAWINGS PROVIDED BY:
Dean & Cheryl
Chouinard

DATE:
8/24/20

SCALE:
1/4" = 1'

SHEET:
3

NEW FLOORPLAN

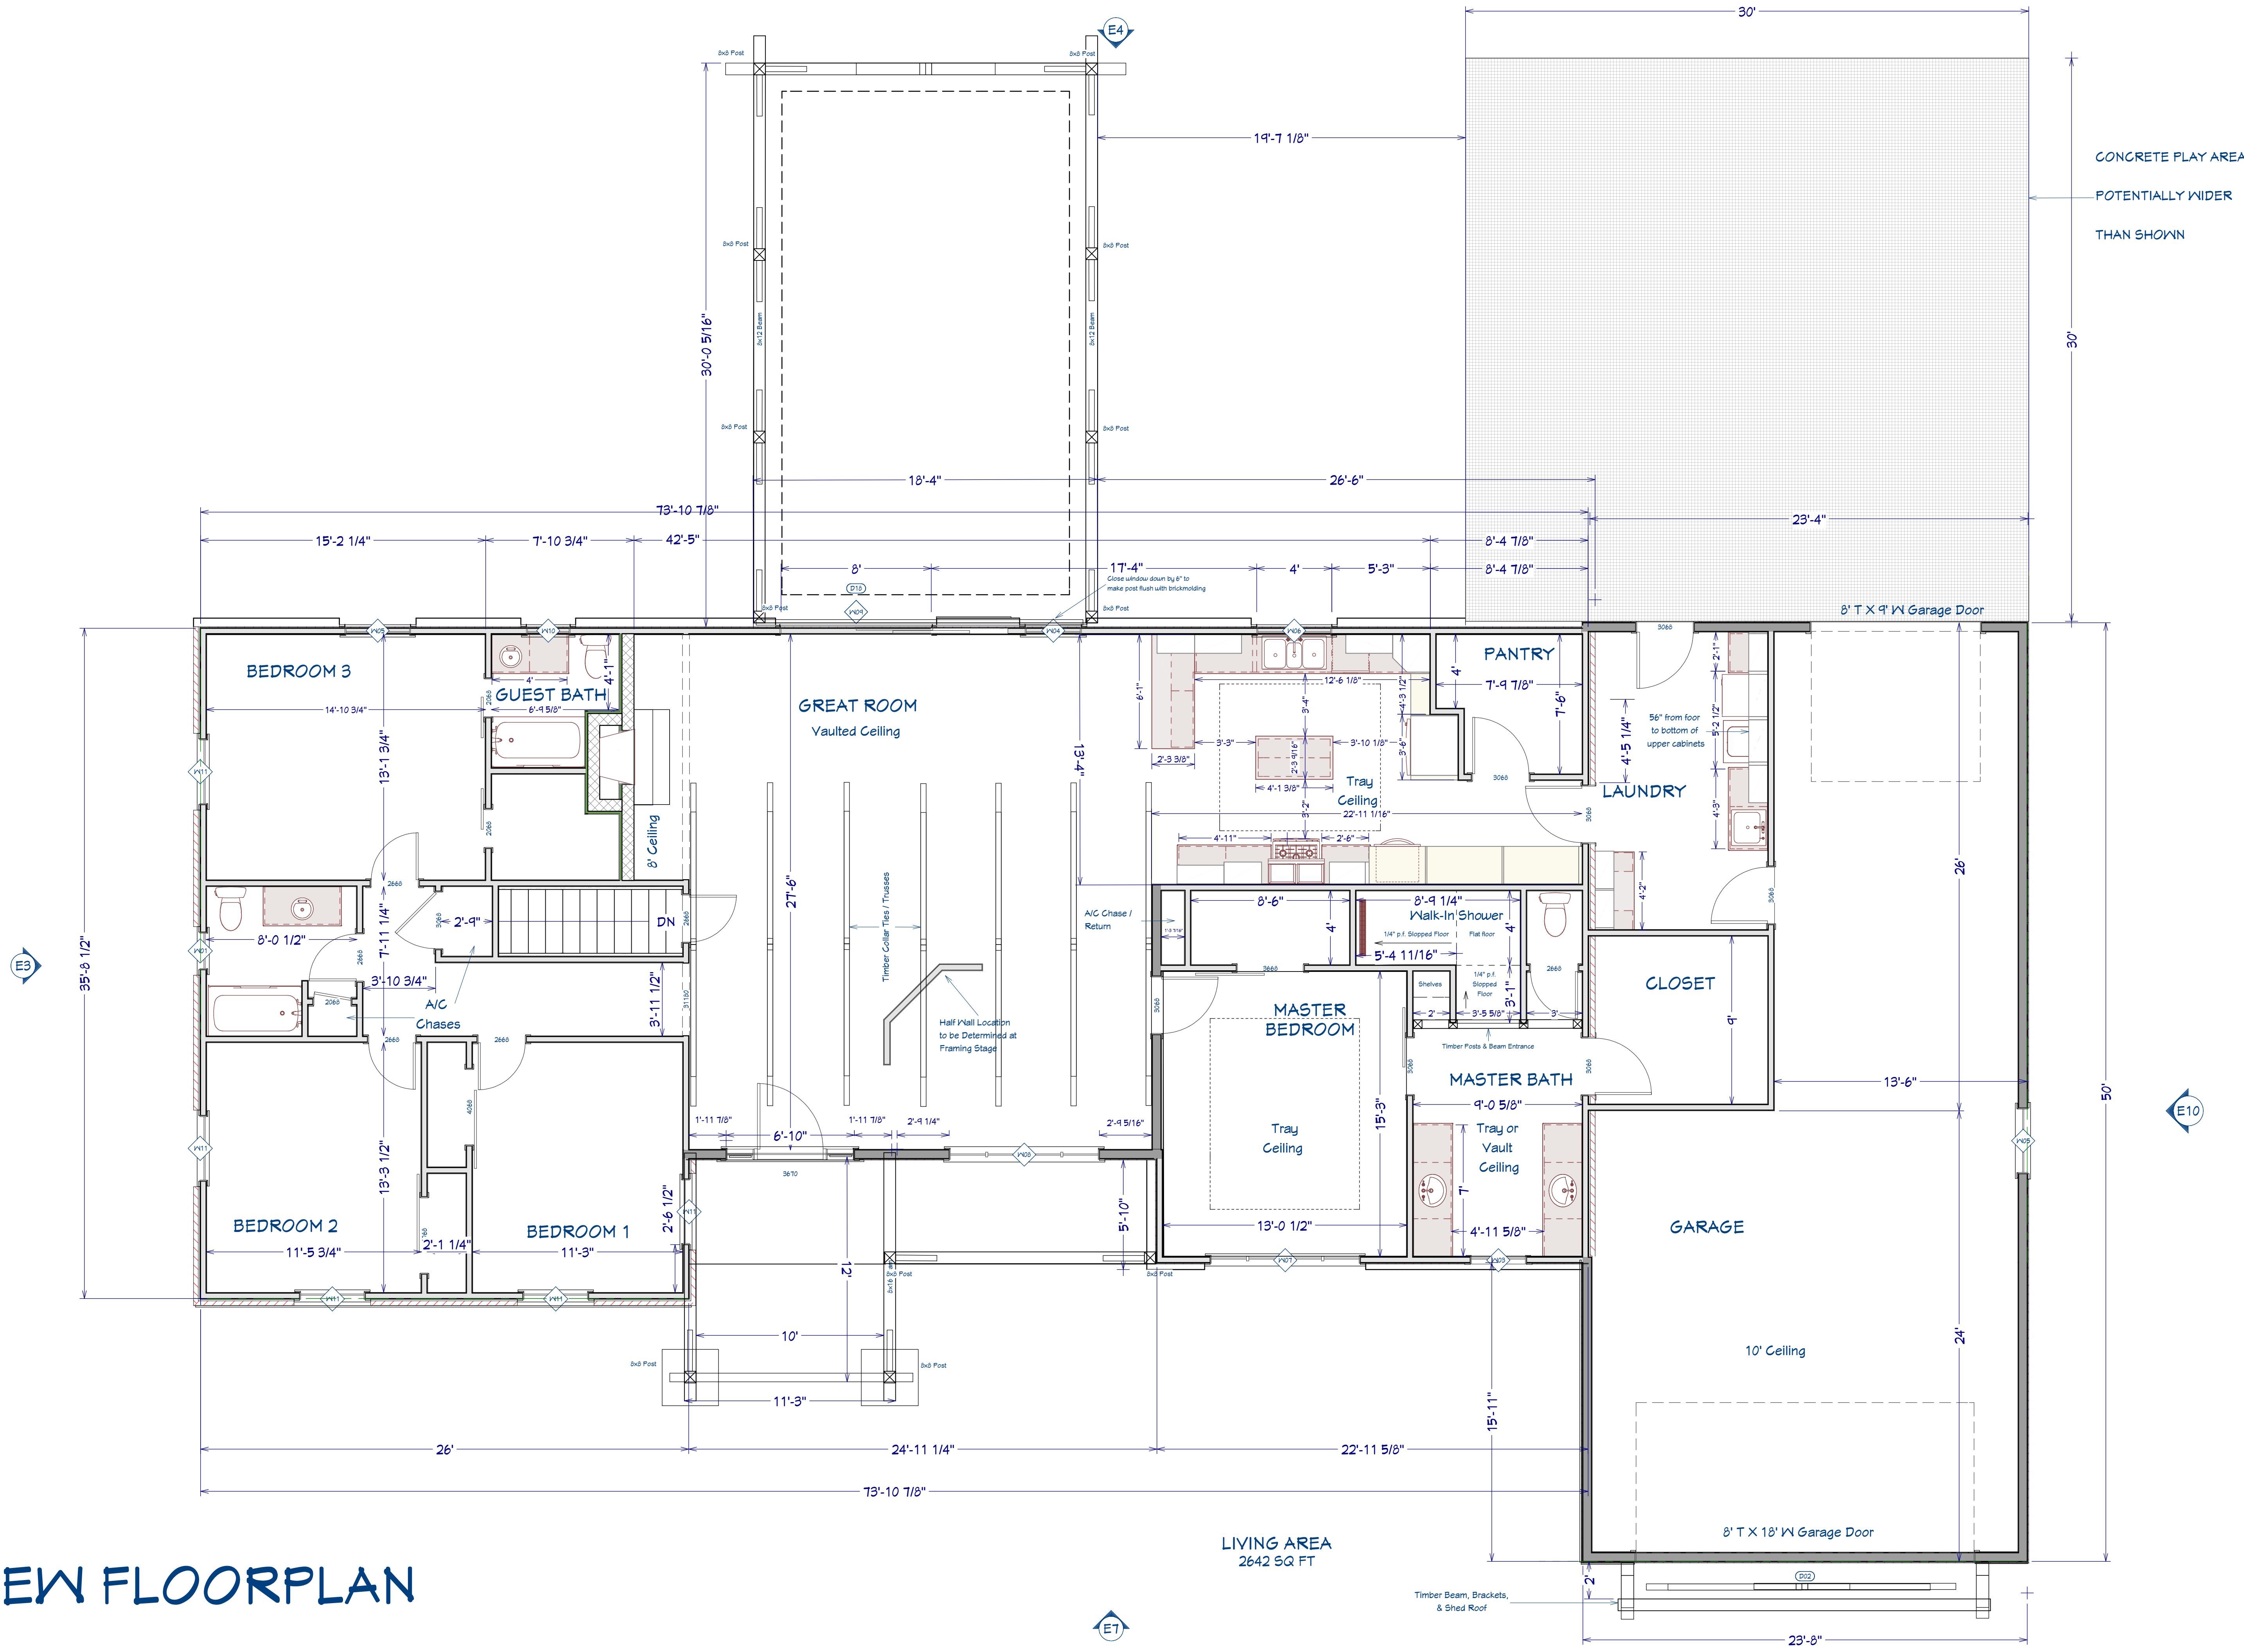

REVISION TABLE

NUMBER	DATE	REVISION BY	DESCRIPTION

703 Eagles Nest Road

Waynesville, NC 28786

DRAWINGS PROVIDED BY:

Dean & Cheryl Chouinard

DATE:

8/24/20

SCALE:

1/4" = 1'

SHEET:

4



Front Elevation



Rear Elevation

FRONT & REAR ELEVATIONS

REVISION TABLE

NUMBER	DATE	REVISION BY	DESCRIPTION

703 Eagles Nest Road

Waynesville, NC 28786

DRAWINGS PROVIDED BY:

Dean & Cheryl Chouinard

DATE:


8/24/20

SCALE:


1/4" = 1'

SHEET:

5

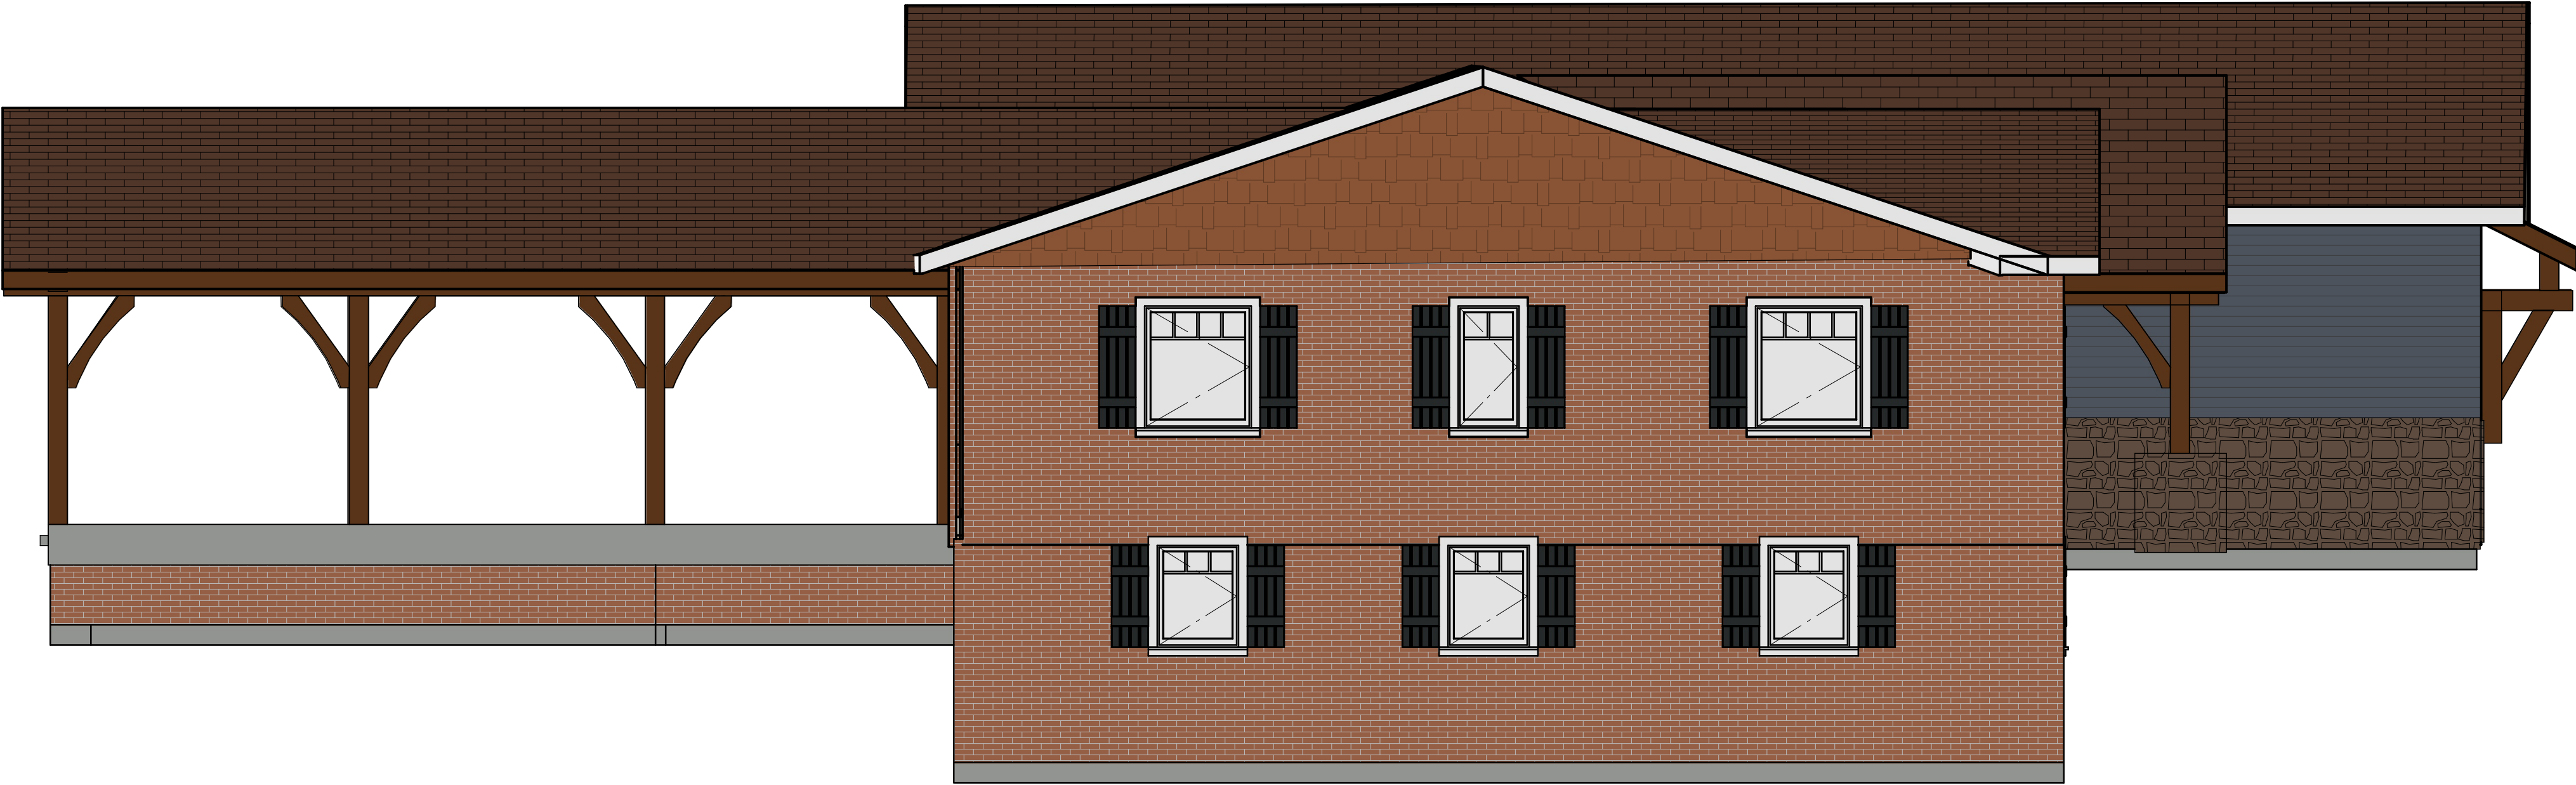

Left Elevation

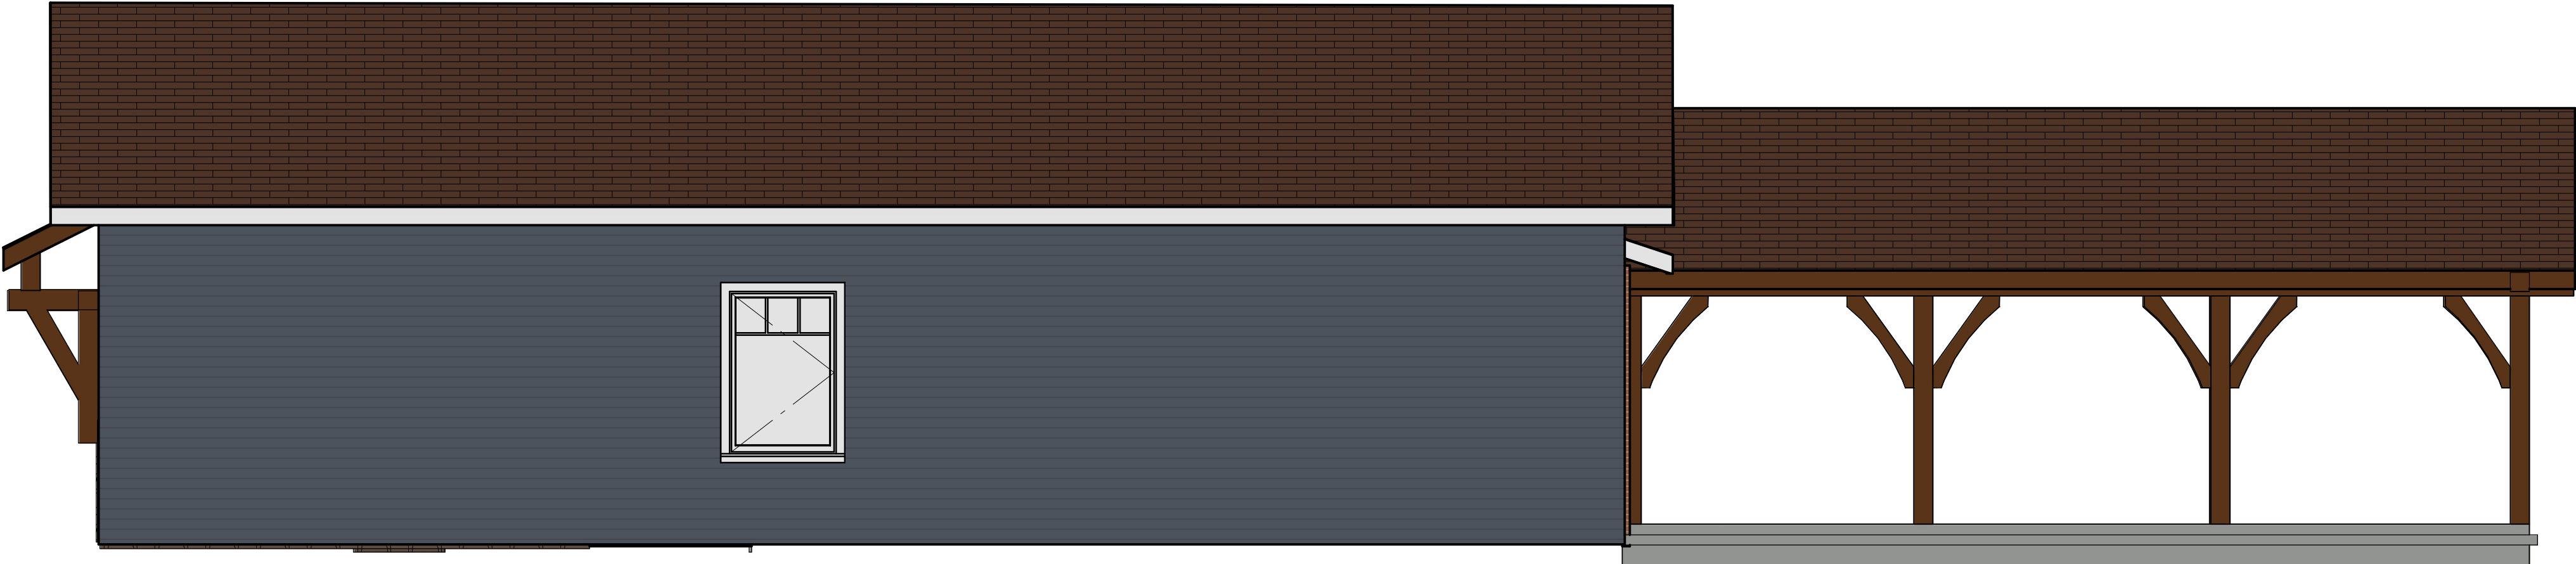

Exterior Elevation Right

NEW HOUSE / LEFT & RIGHT ELEVATIONS

--

REVISION TABLE		
NUMBER	DATE	DESCRIPTION

703 Eagles Nest Road
Waynesville, NC 28786

--

DRAWINGS PROVIDED BY:
Dean & Cheryl
Chouinard

DATE:

8/24/20

SCALE:


1/4" = 1'

SHEET:

6




FRONT LEFT 3D

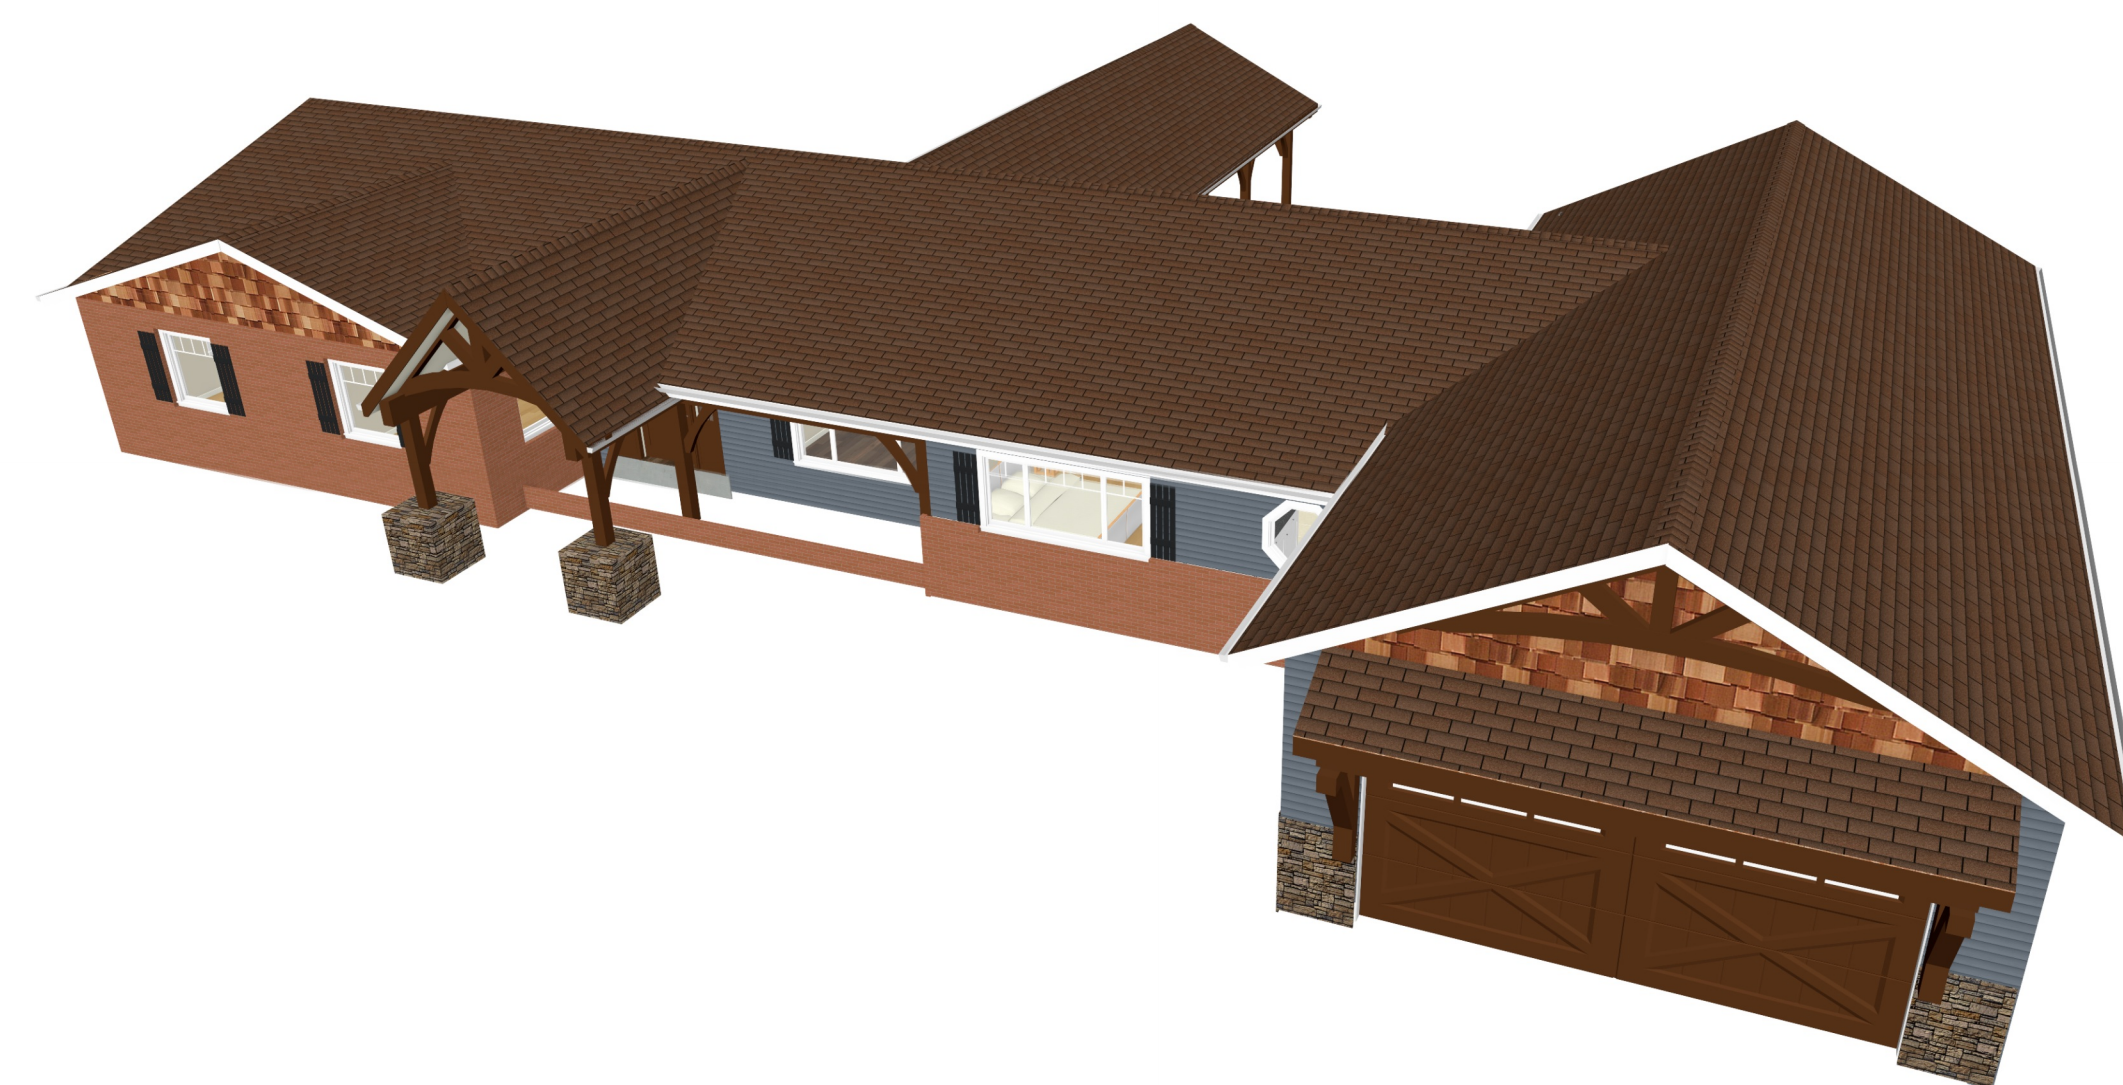

FRONT RIGHT 3D



REAR 3D

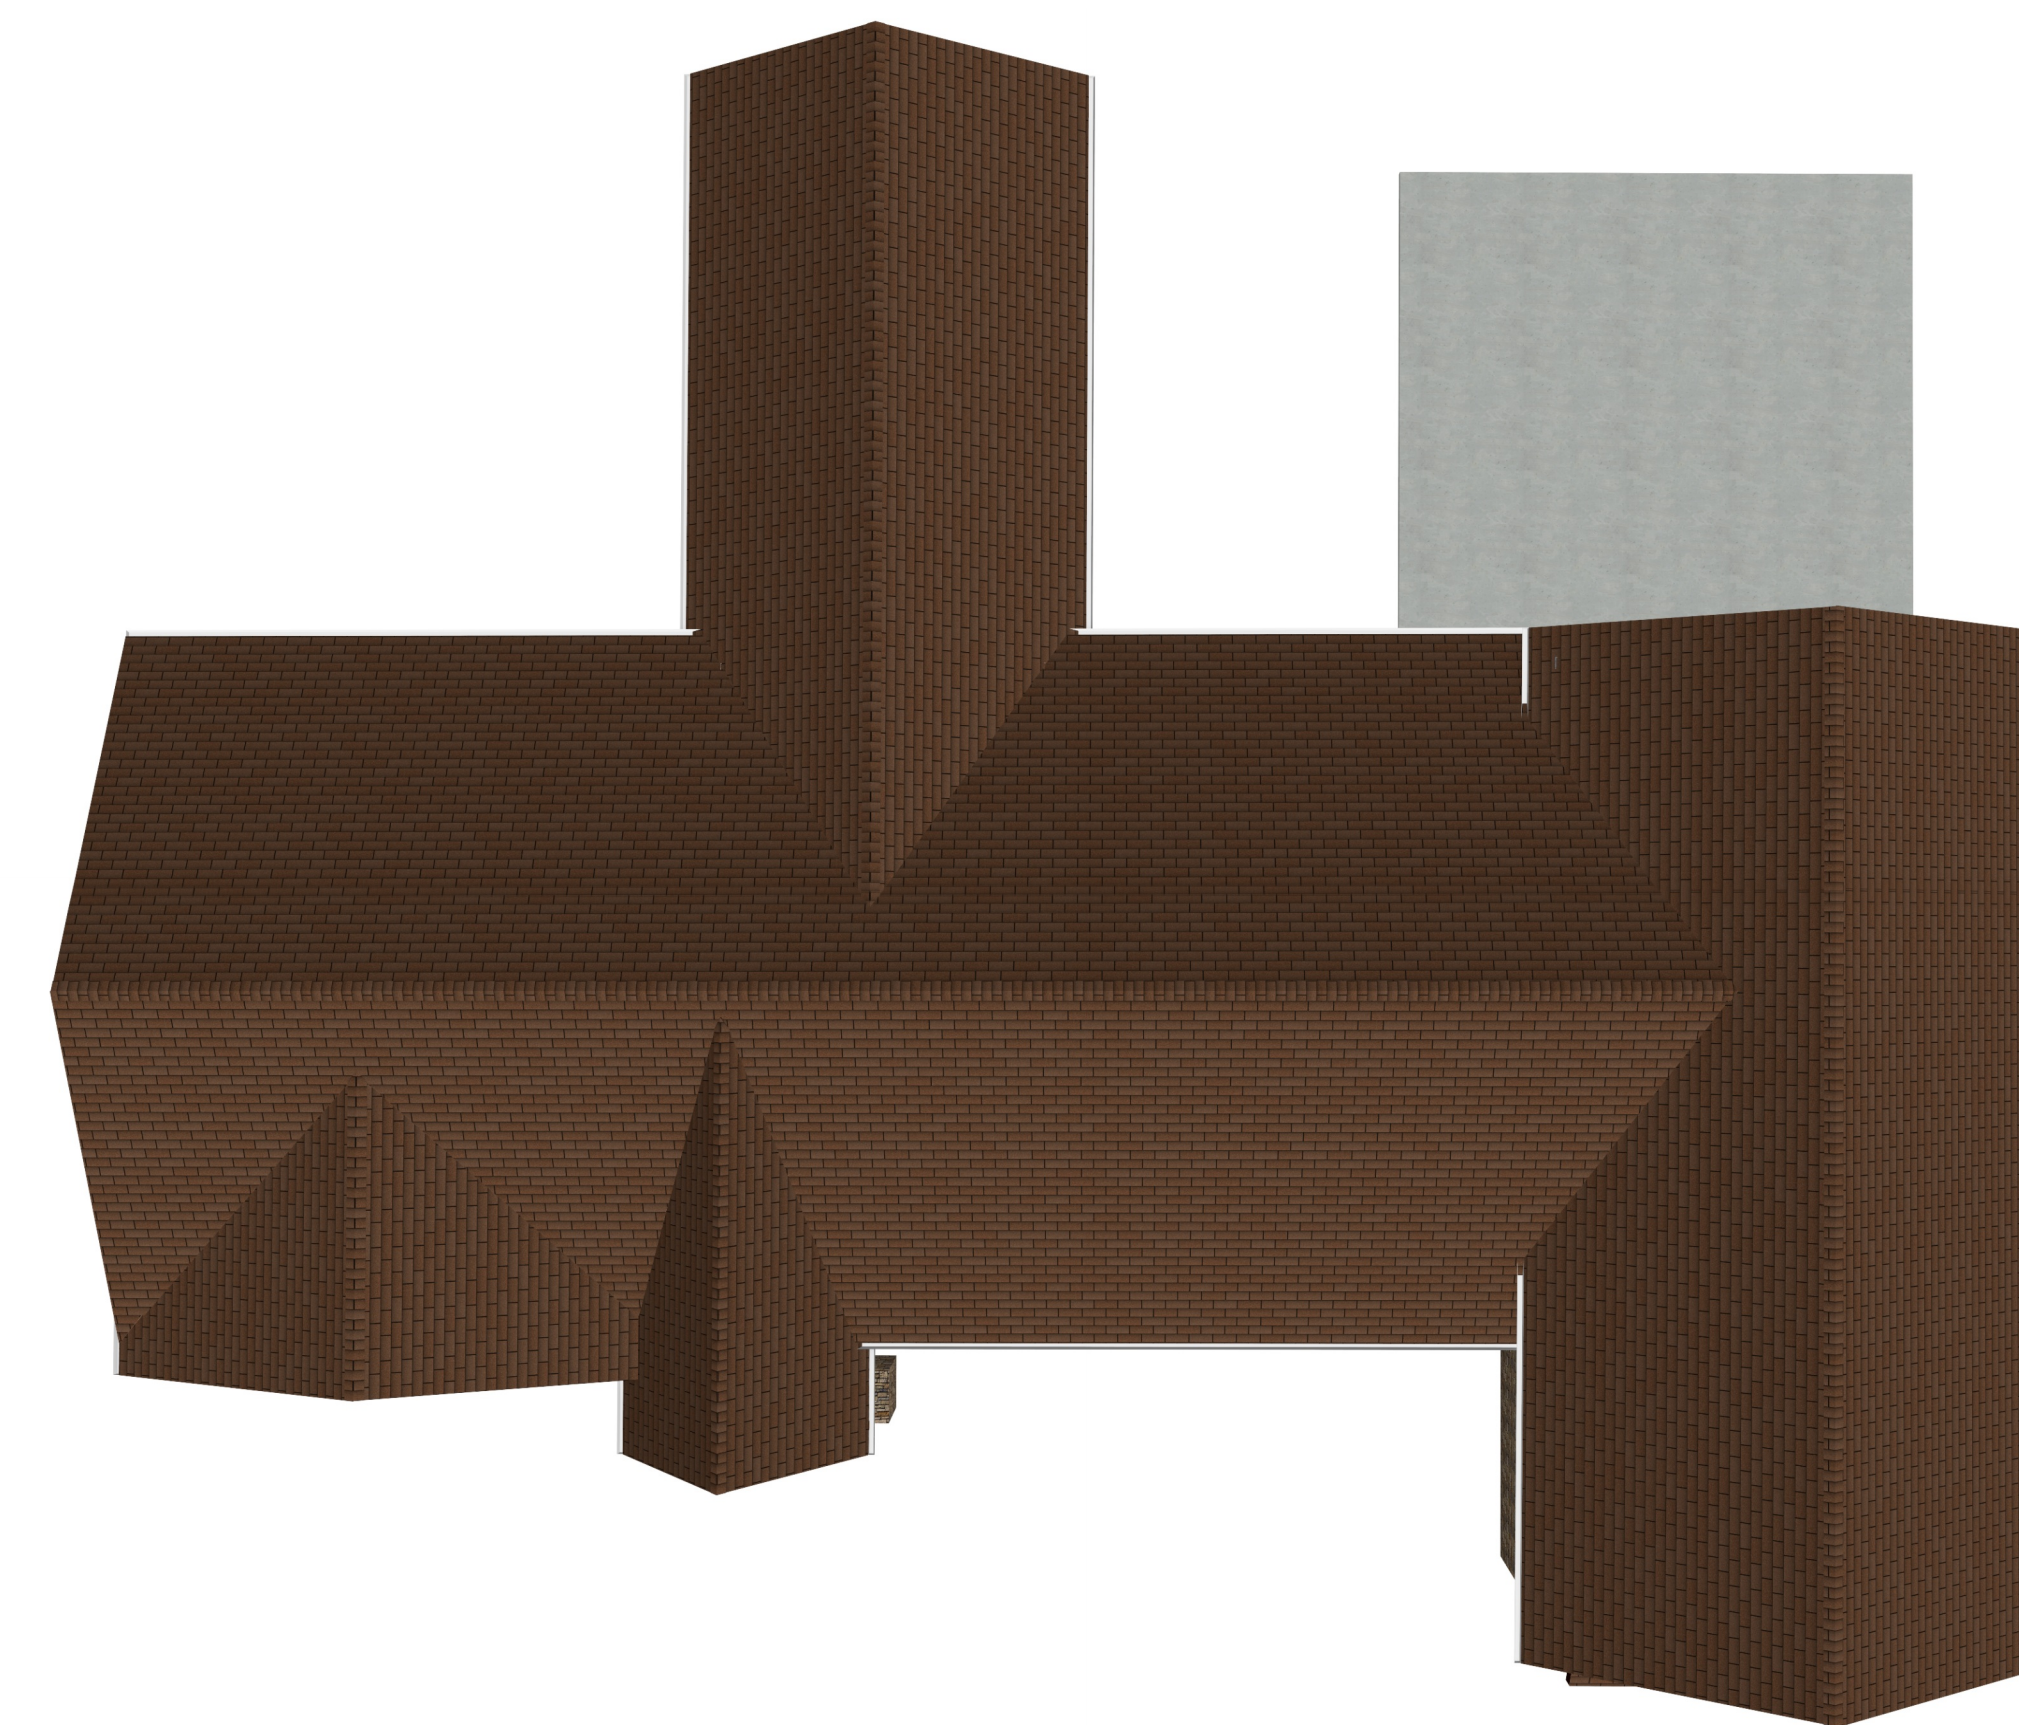

ROOF 3D

3D VIEWS

REVISION TABLE	
NUMBER	DESCRIPTION

703 Eagles Nest Road
Waynesville, NC 28786

DRAWINGS PROVIDED BY:
Dean & Cheryl
Chouinard

DATE:


8/5/20

SCALE:


1/4" = 1'

SHEET:


7

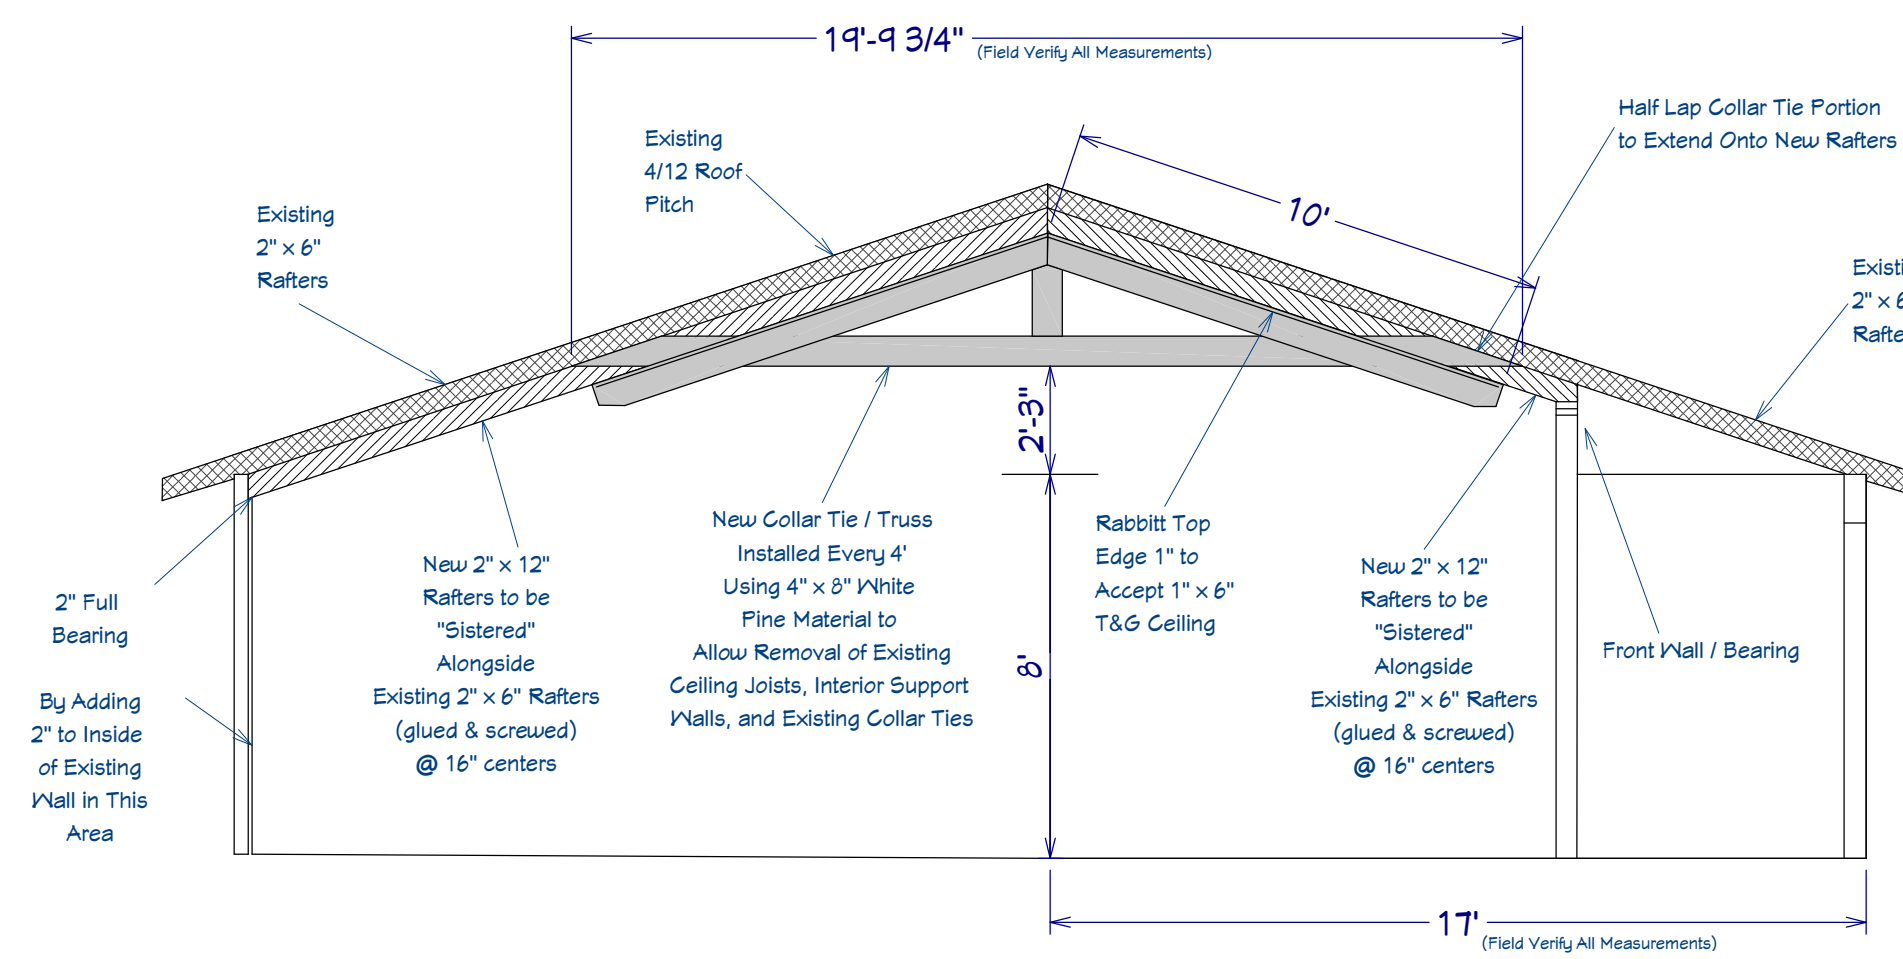


New "Sistered" 2" x 12"
Rafters w/ New
Timber Collar Ties

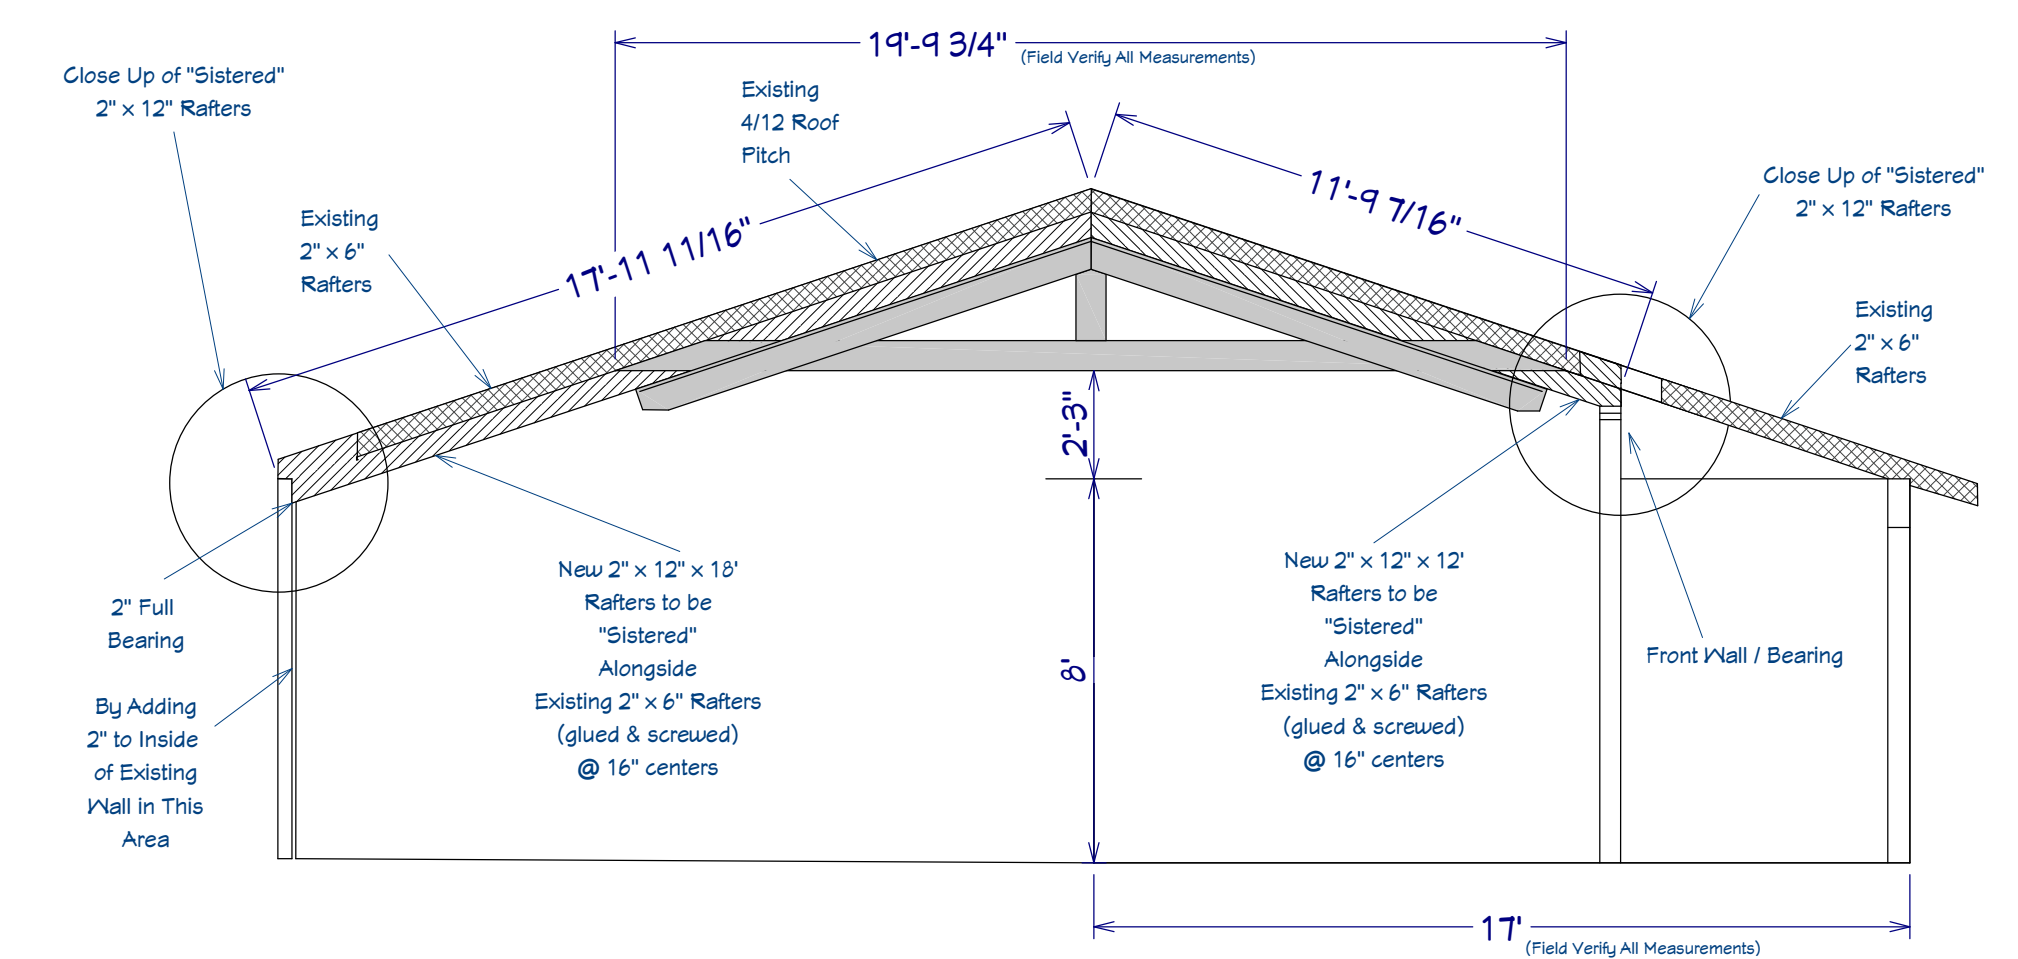


'Sistered' Rafters Bearing Closeup

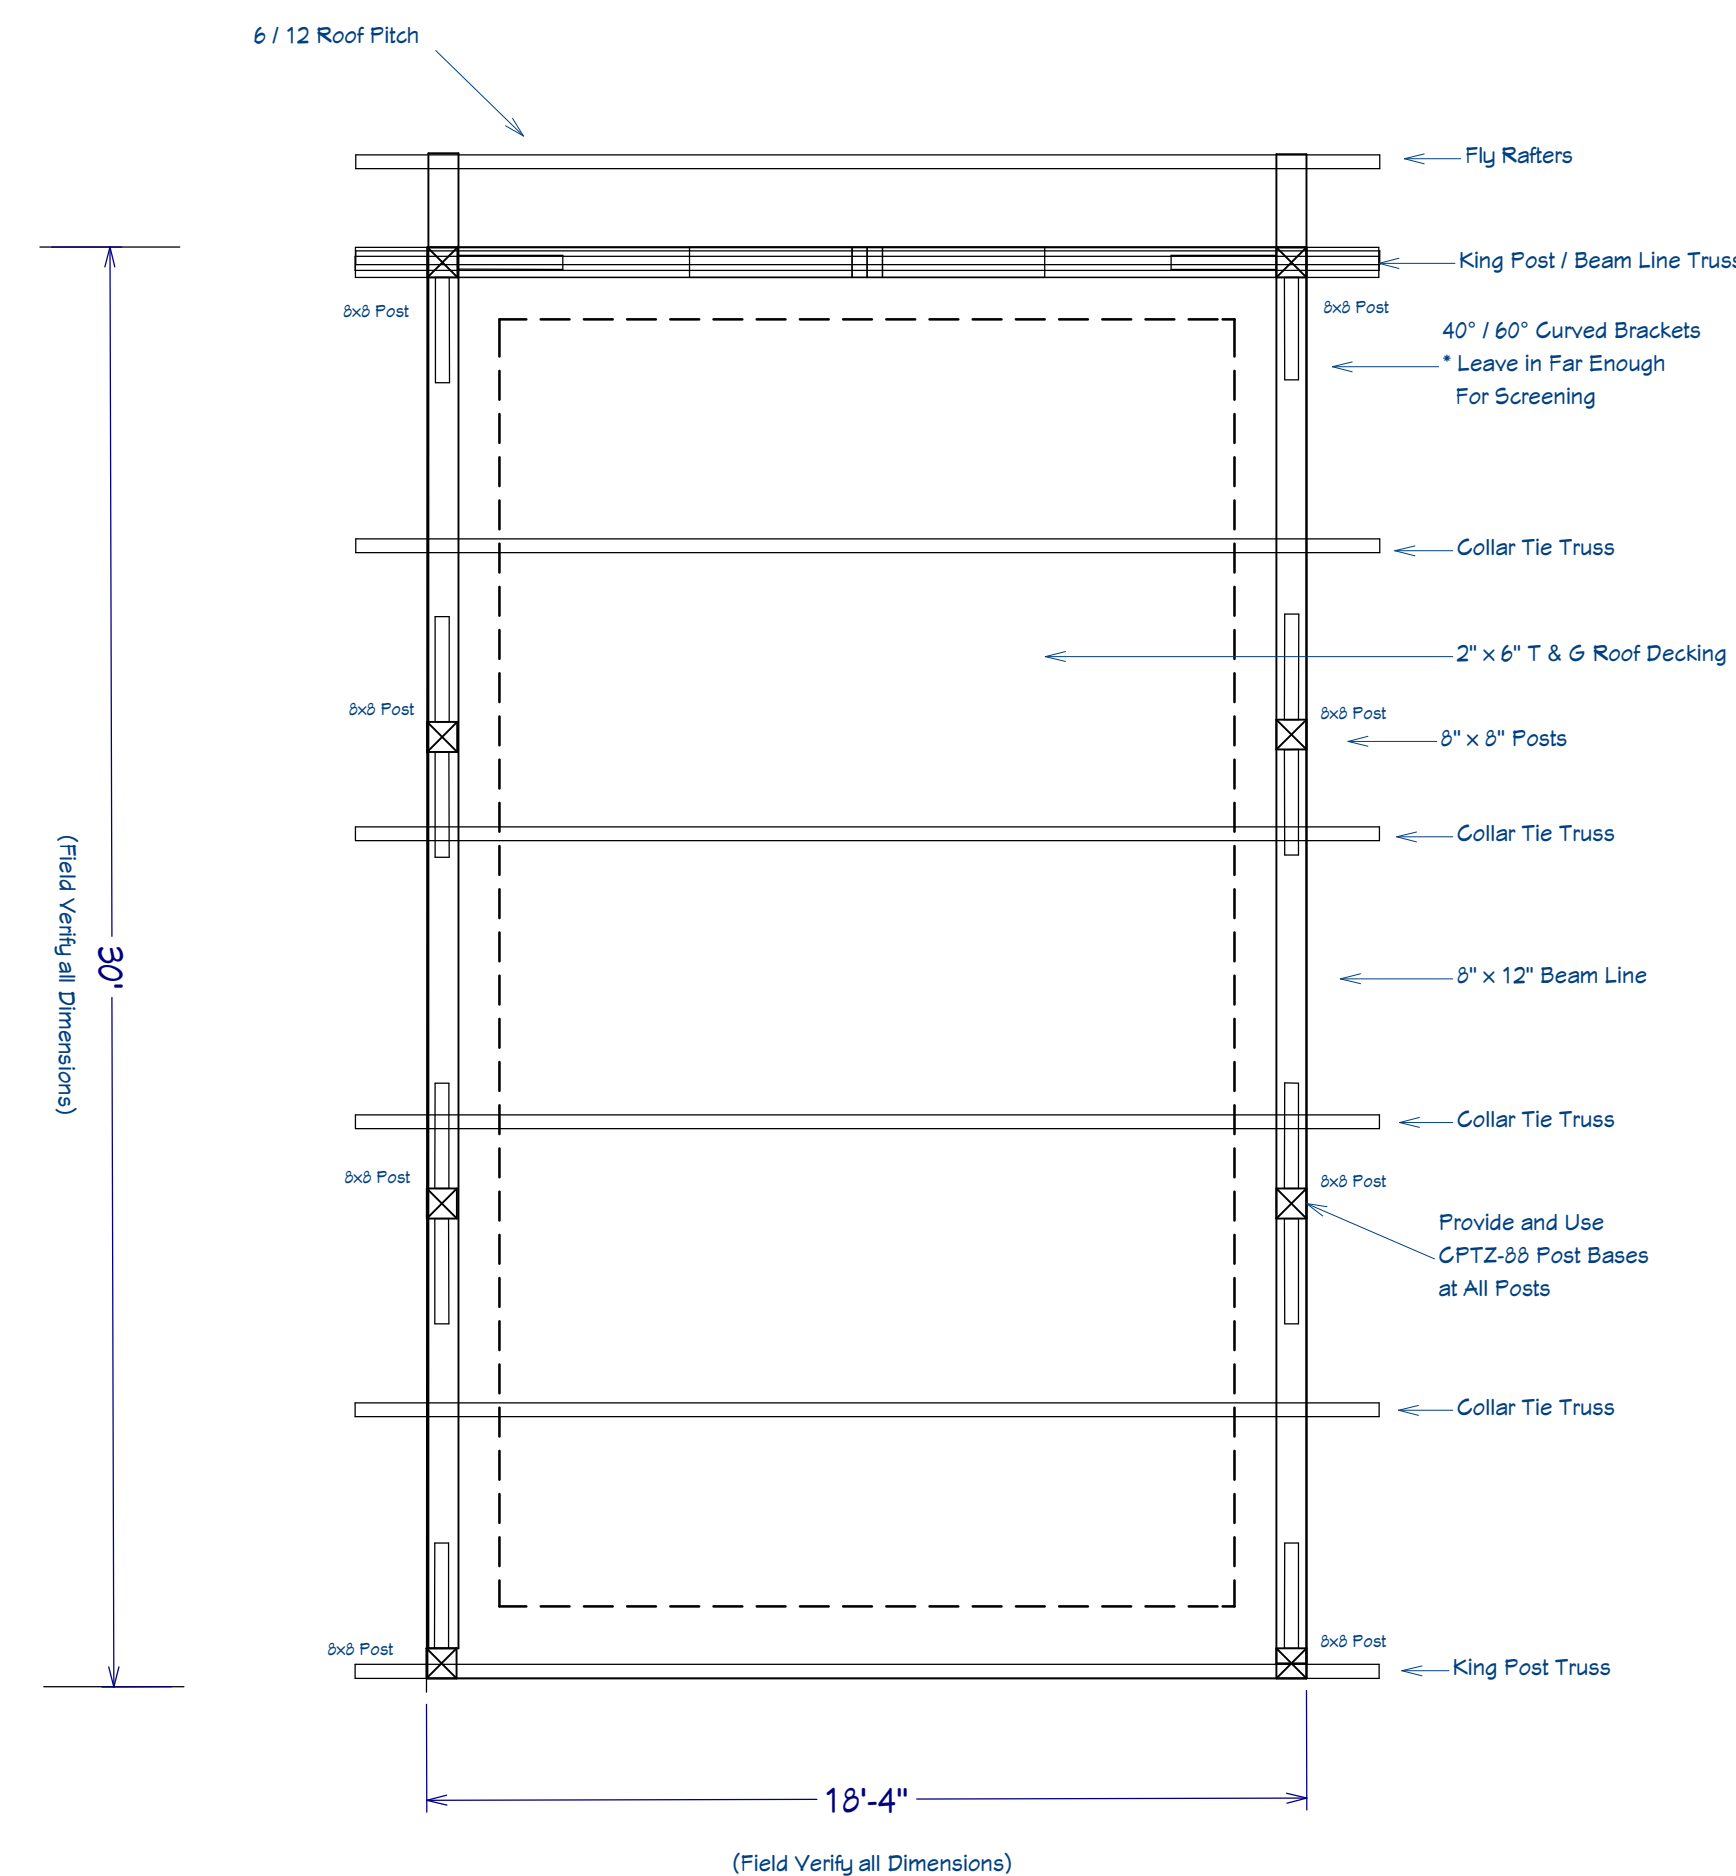

Timber Rear Porch

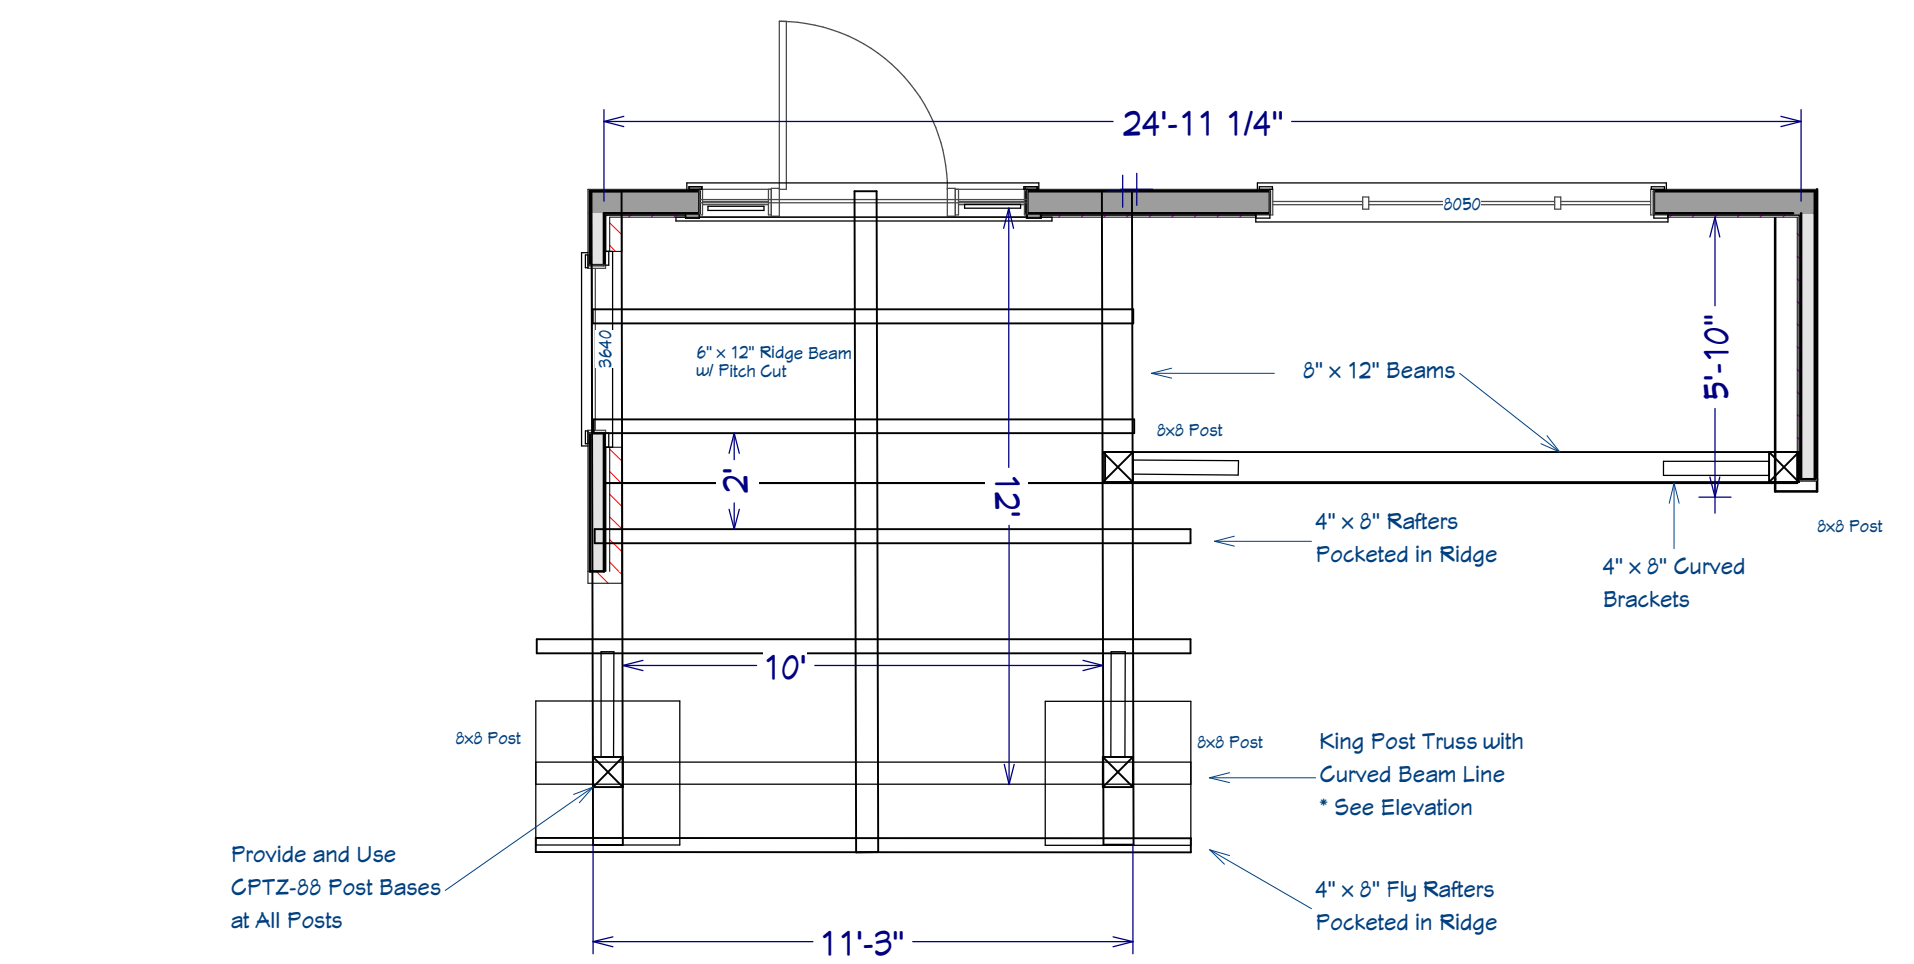

Front Porch Timbers
(See Elevation)

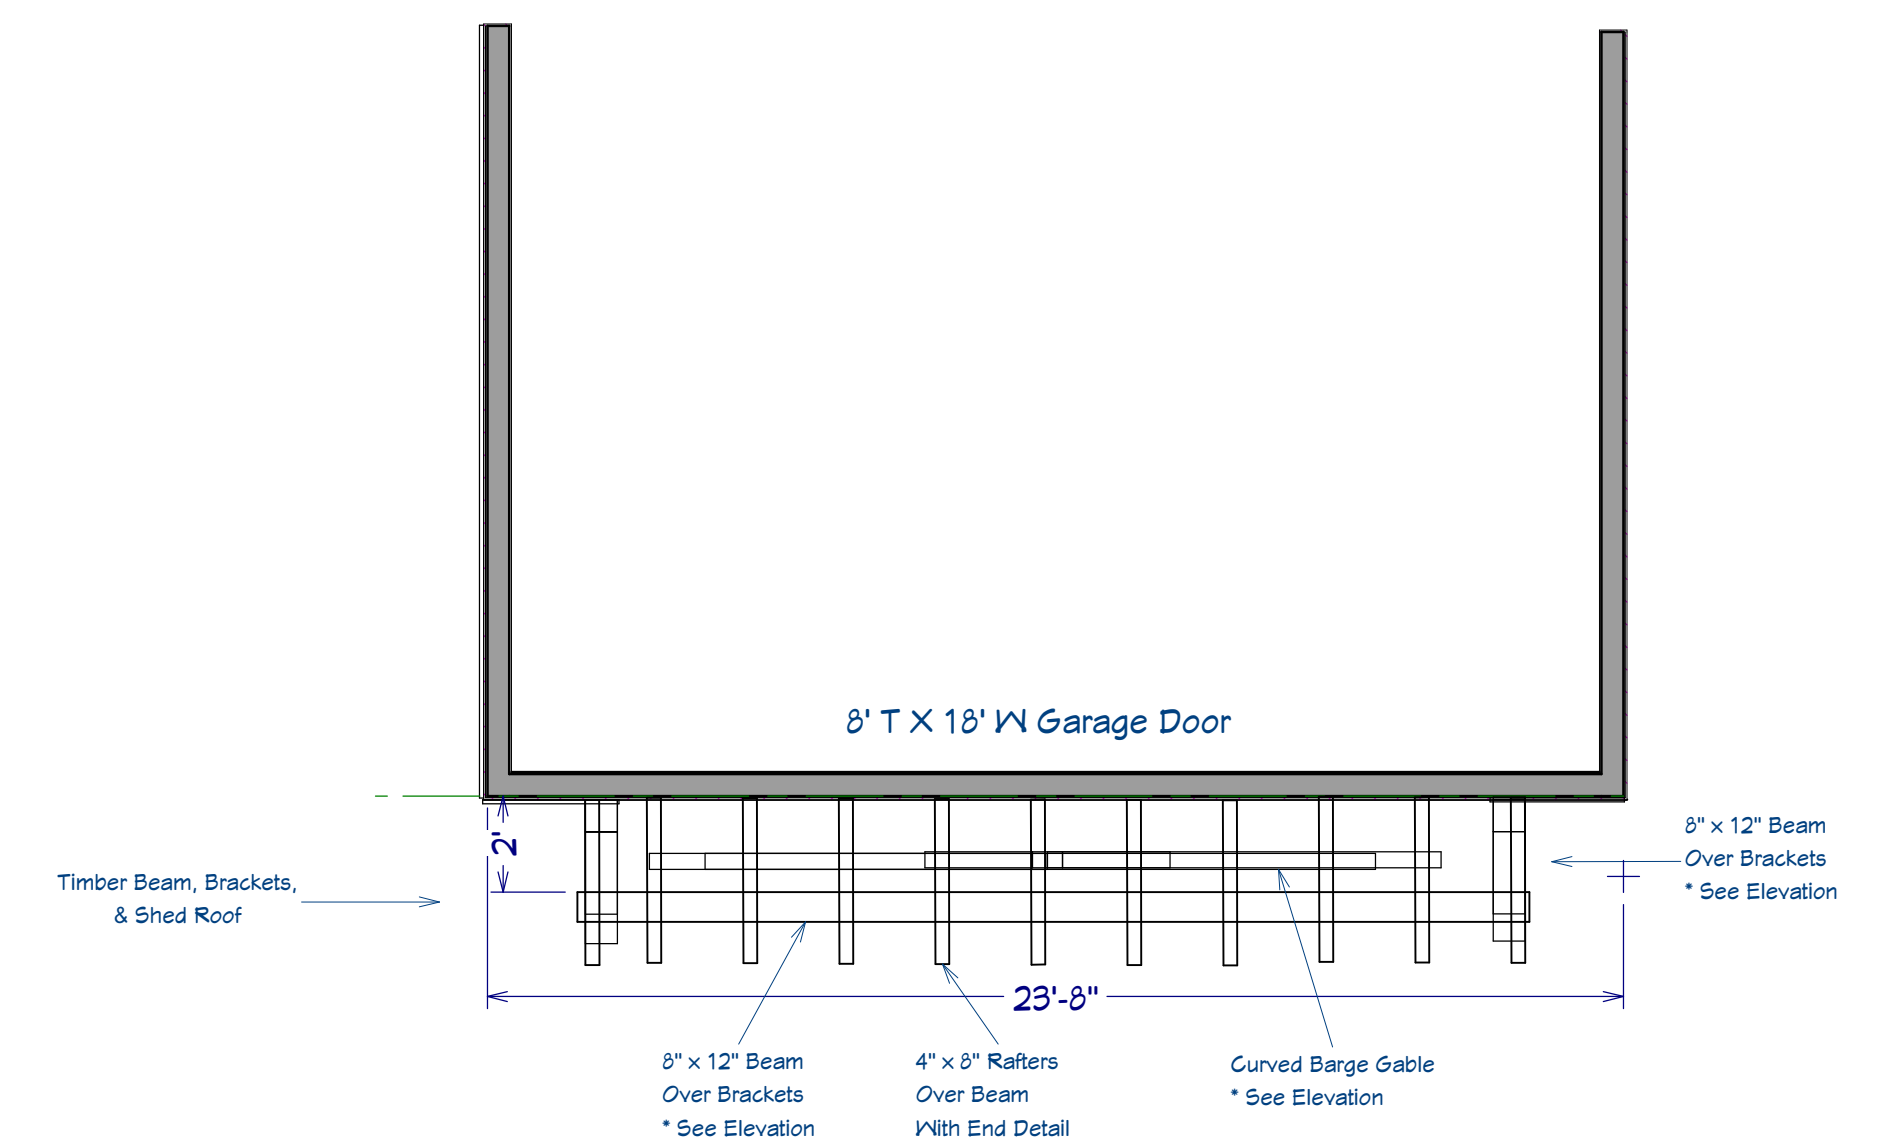

Timber @ Garage



TIMBER DETAILS

[illegible]

703 Eagles Nest Road
Waynesville, NC 28786


Dean & Cheryl
Chouinard

DATE:
/24/20


SCALE:

$1/4" = 1'$

SHEET:

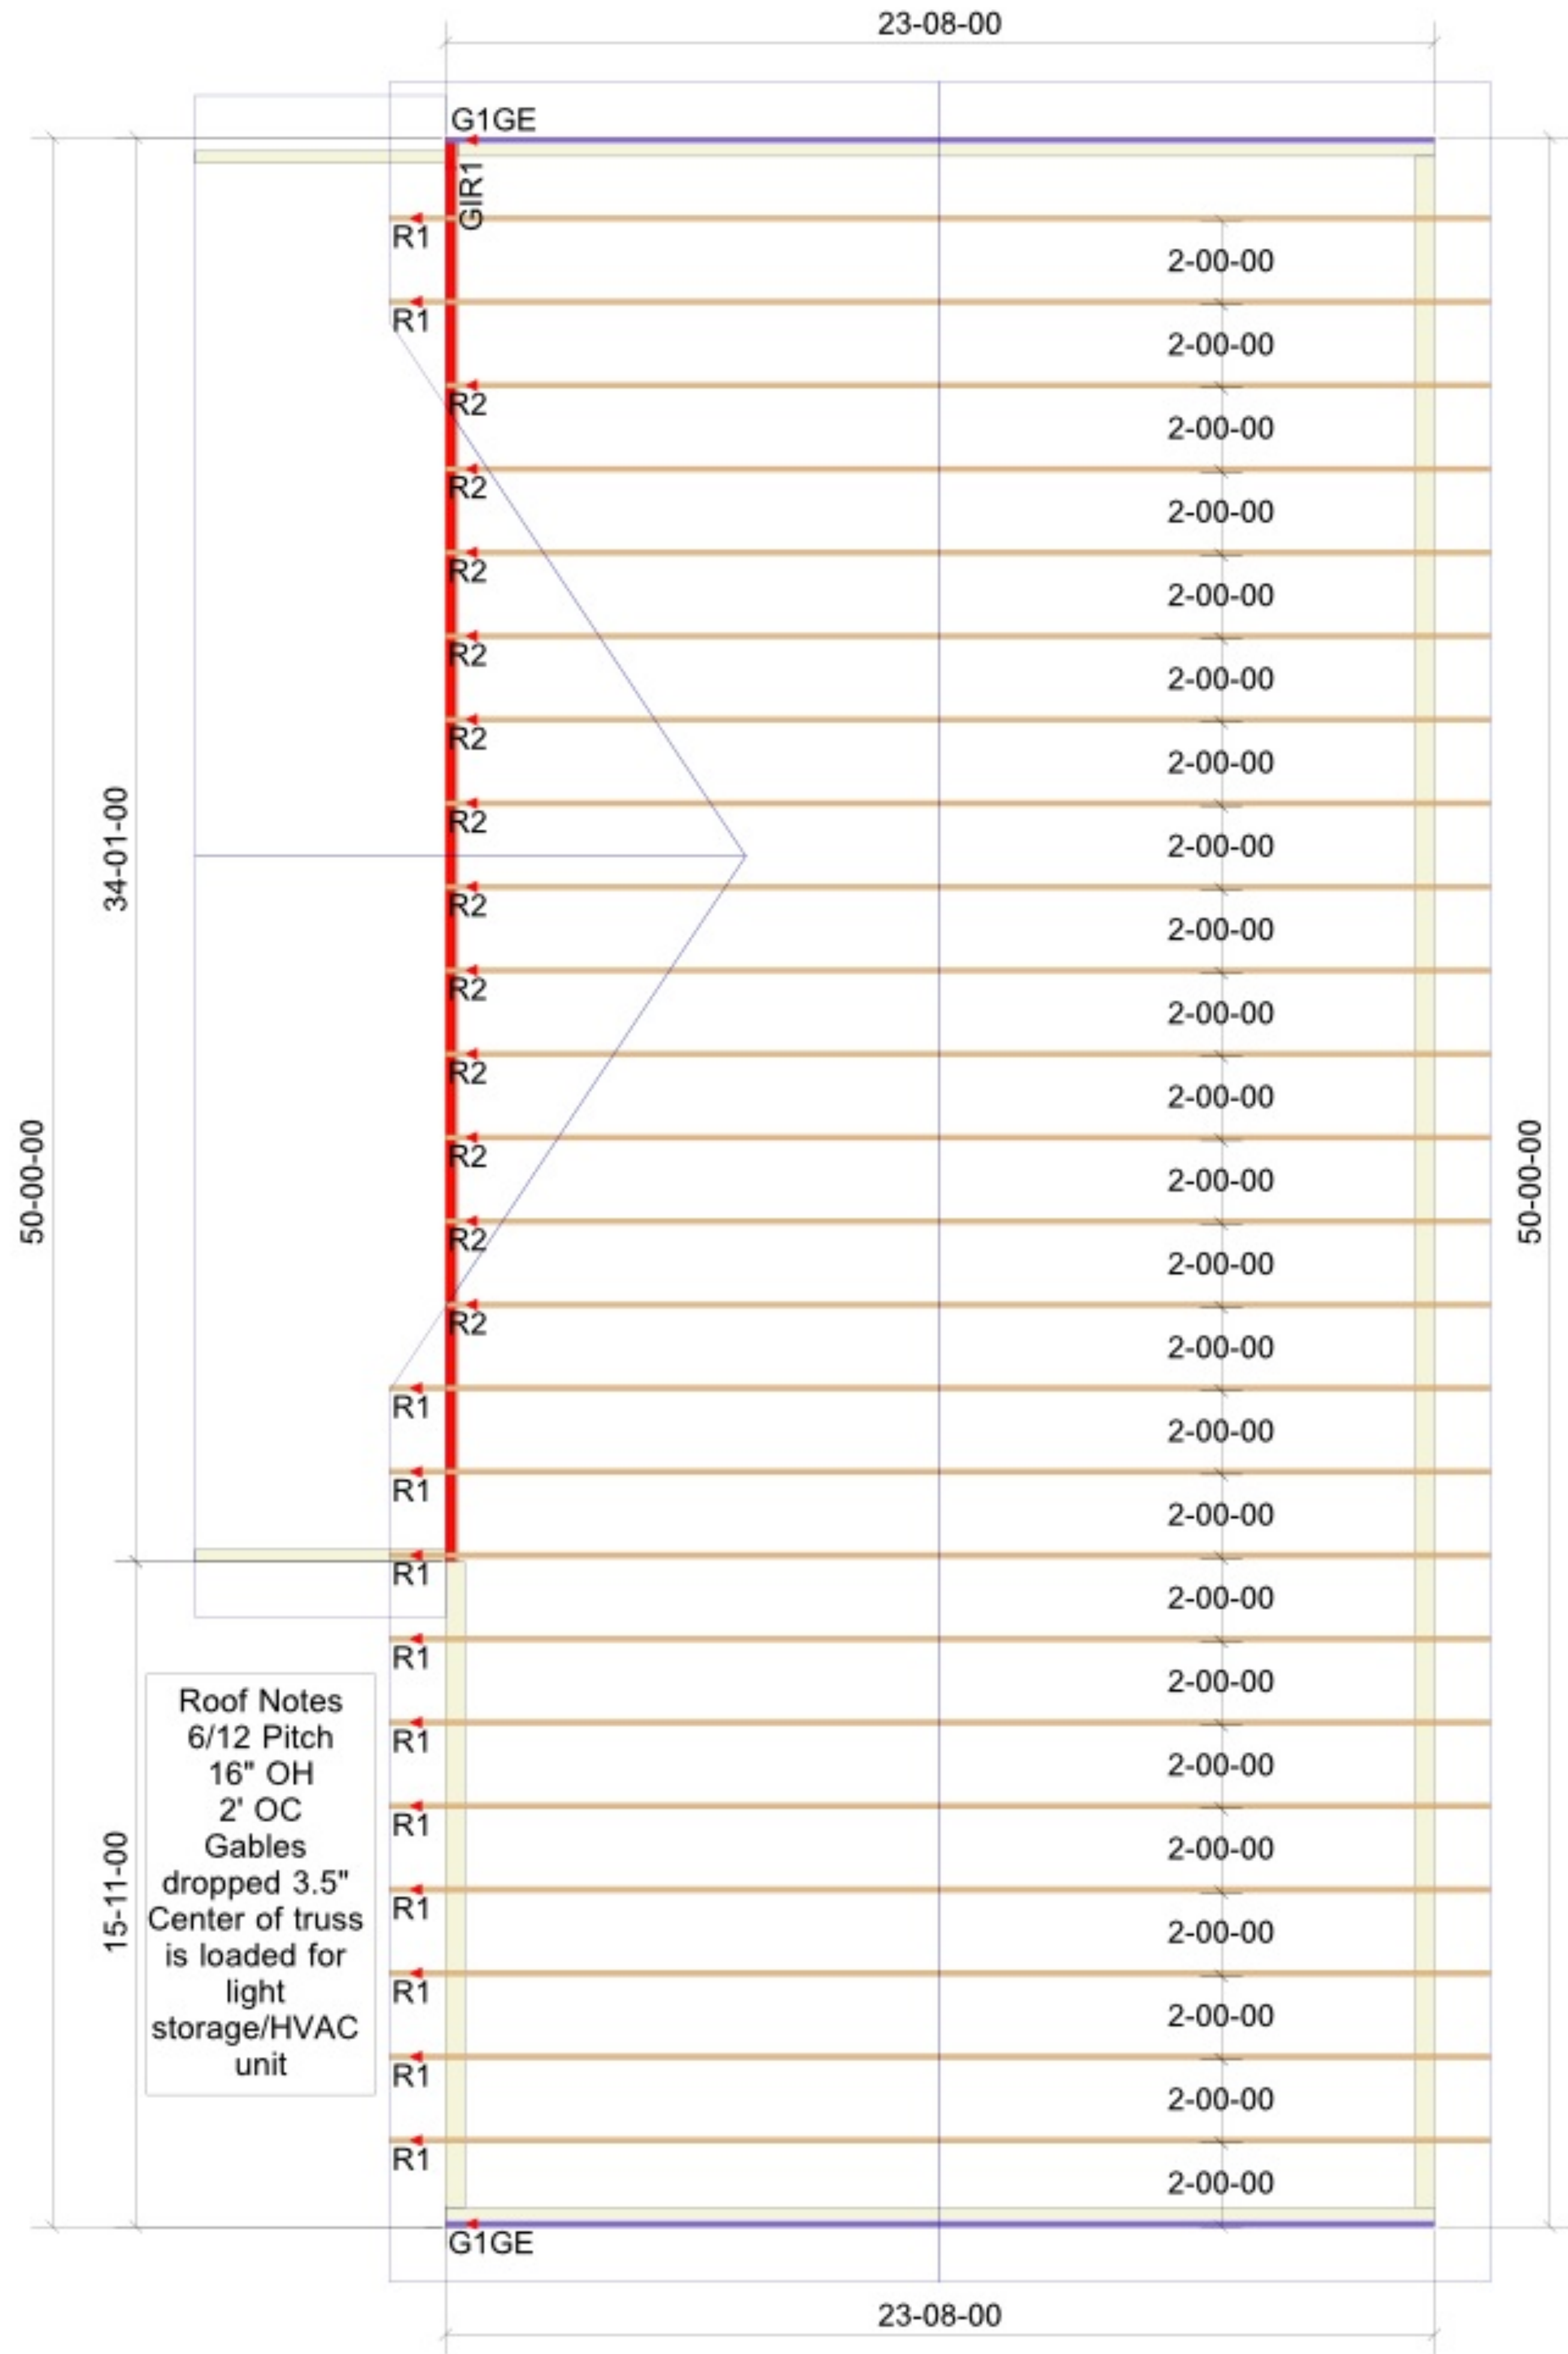

NEW TRUSS LAYOUT / GARAGE

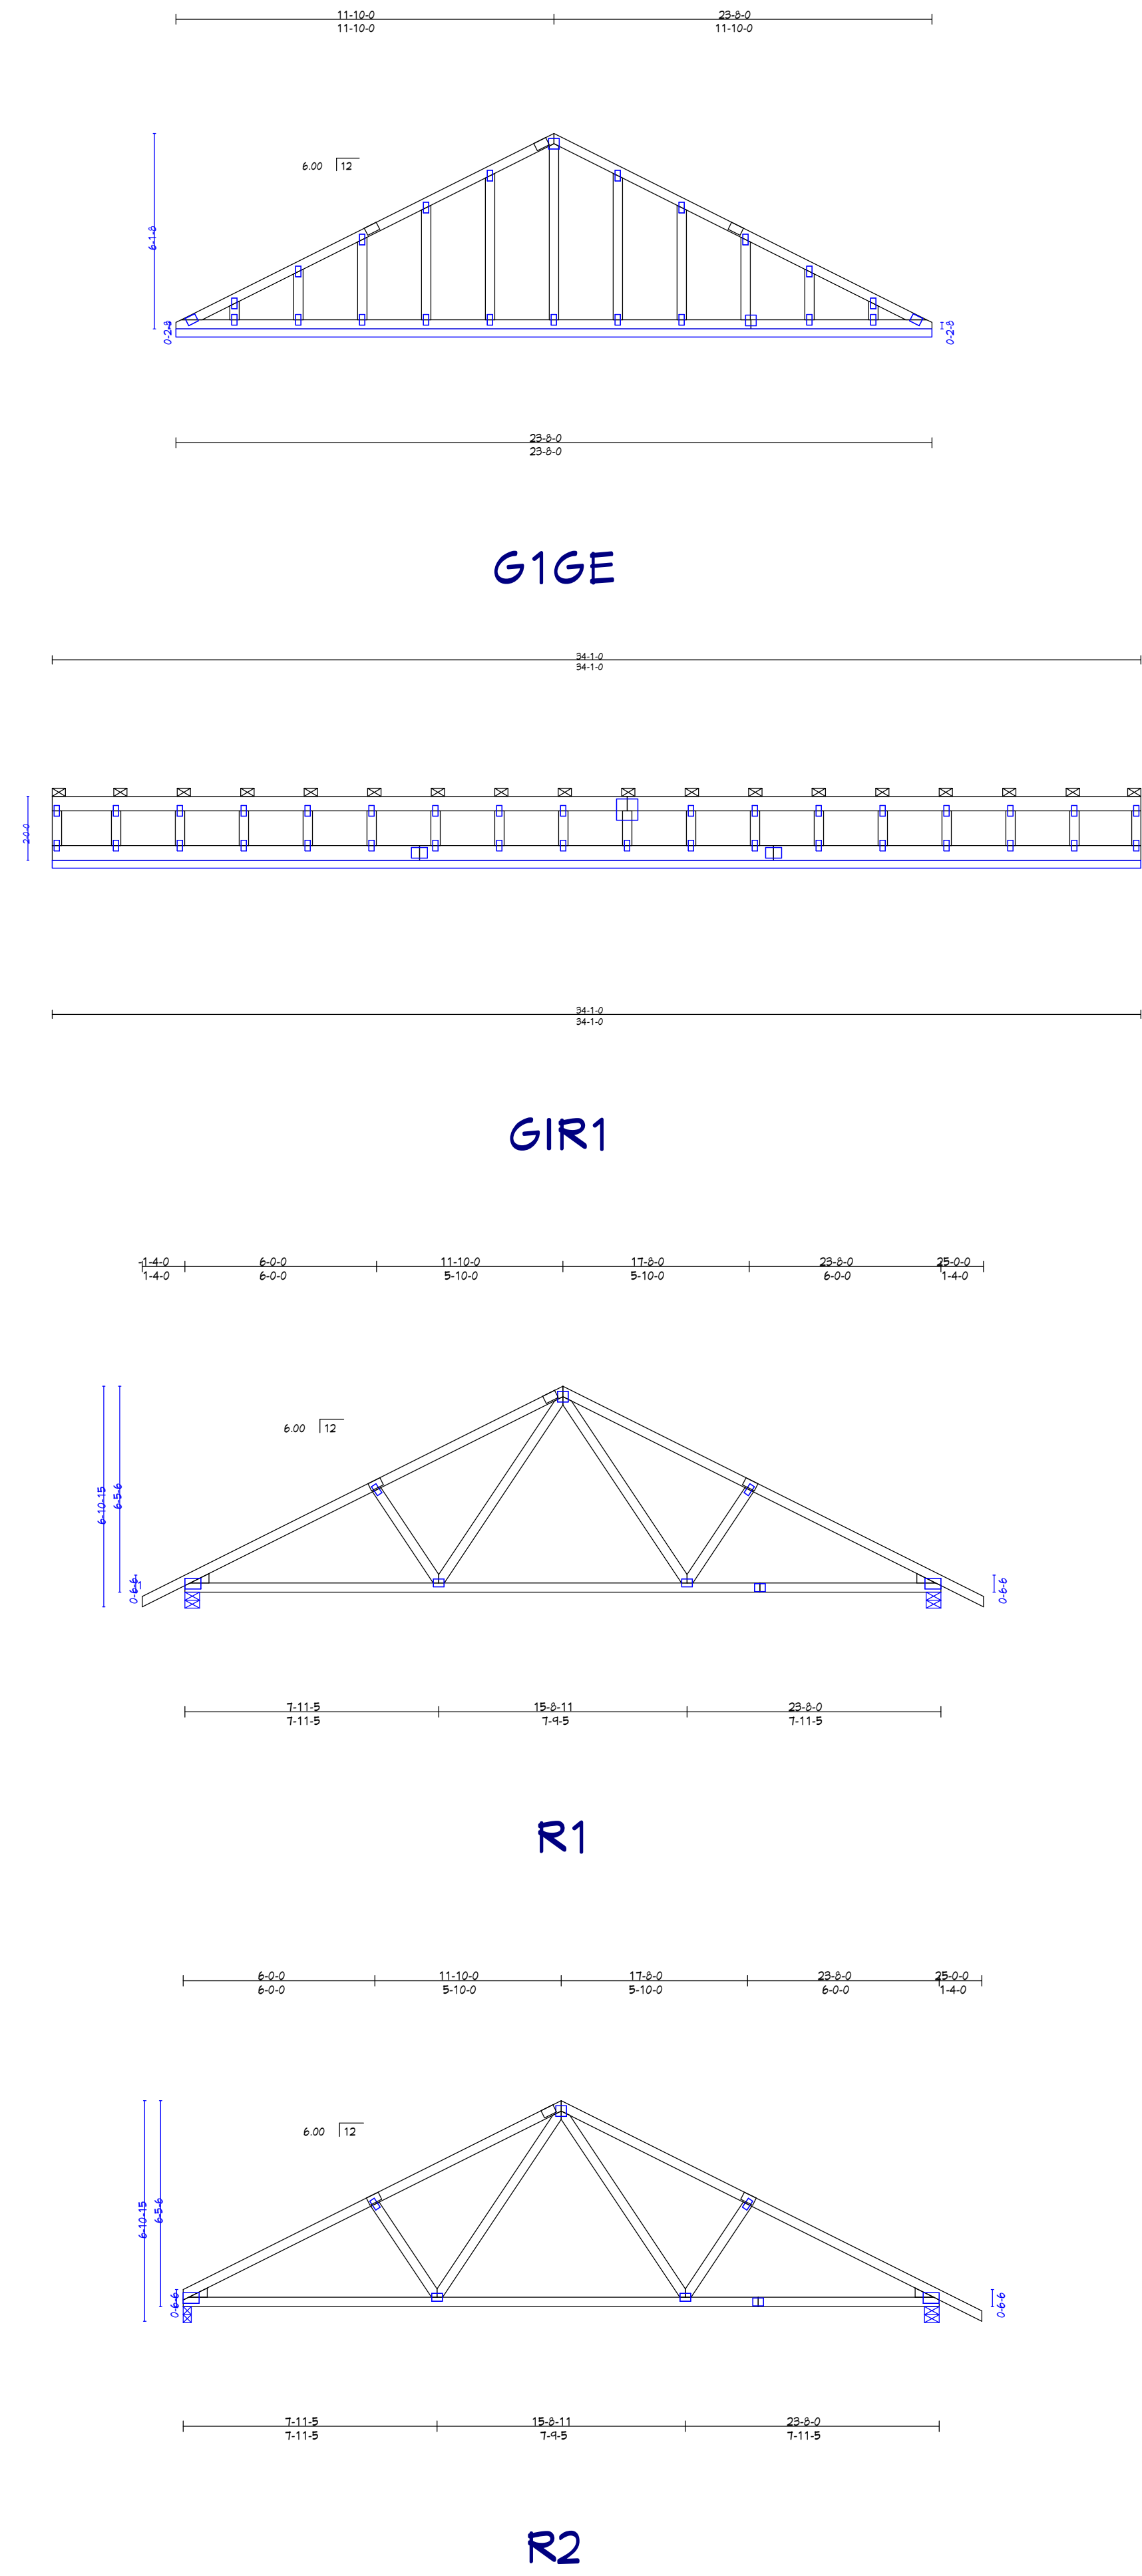

REVISION TABLE	
NUMBER	DATE












703 Eagles Nest Road
Waynesville, NC 28786

DRAWINGS PROVIDED BY:
Dean & Cheryl Chouinard

DATE:
8/24/20

SCALE:
1/4" = 1'

SHEET:
9

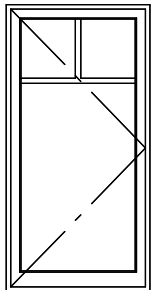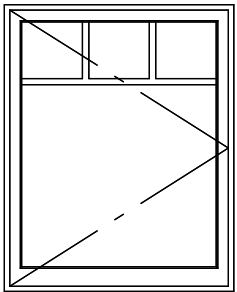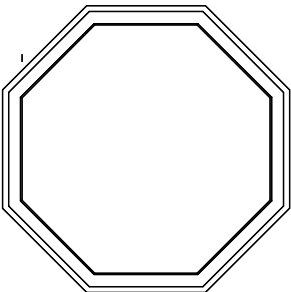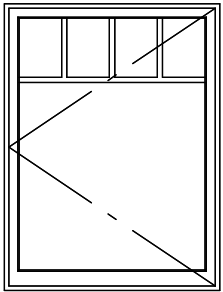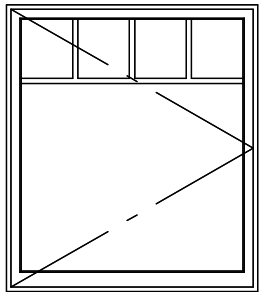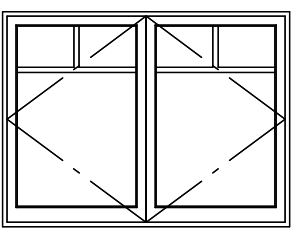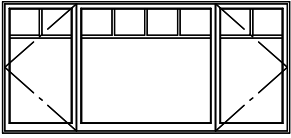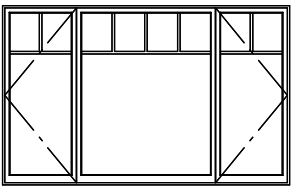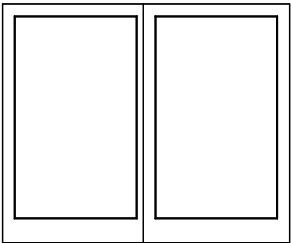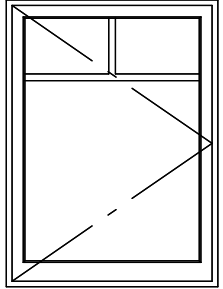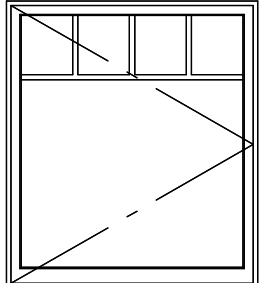SEE EXTERIOR ELEVATION	NUMBER	LABEL	QTY	SIZE	BSG	DESCRIPTION	WINDOW SCHEDULE	COMMENTS
	W01	2040	1	2040	25"x41"	SINGLE CASEMENT-HR		
	W02	2034SG	5	2034SG	35"x41"	SINGLE CASEMENT-HR		THESE BASEMENT WINDOWS ARE REPLACING SINGLE PANE ALUMINUM SINGLE HUNG WINDOWS, SO WE COULD POTENTIALLY SAVE SOME MONEY HERE VERSUS USING THE DOUBLE PANE LOWE'S ARSON GLASS, BUT I DO NOT WANT A SINGLE OR DOUBLE HUNG BAR GOING THROUGH THE GLASS, AS THESE NEED TO MATCH WHAT IS ABOVE THEM. (SEE ELEVATIONS)
	W03	3030	1	3030	37"x37"	FIXED GLASS-AT		OPSCURE GLASS SOUND DAMPENING GLASS IF POSSIBLE, OR MAYBE LAMINATED GLASS OR EVEN TRIPLE PANE?
	W04	3040	1	3040	37"x41"	SINGLE CASEMENT-HL		
	W05	3640	2	3640	43"x41"	SINGLE CASEMENT-HR		
	W06	4050	1	4050	41"x57"	DOUBLE CASEMENT-LH/RH-HR		MAYBE PRICE AN AVINING OPTION TO ELIMINATE THE CENTER FRAMES?
	W07	5030	1	5030	47"x45"	TRIPLE CASEMENT-LH/LR-HR		SOUND DAMPENING GLASS IF POSSIBLE, OR MAYBE LAMINATED GLASS OR EVEN TRIPLE PANE?
	W08	5050	1	5050	47"x61"	TRIPLE CASEMENT-LH/LR-HR		SOUND DAMPENING GLASS IF POSSIBLE, OR MAYBE LAMINATED GLASS OR EVEN TRIPLE PANE?
	W09	5060	1	5060 R EX	147"x52 1/2"	EXT. 0+2-PANEL POCKET-GLASS PANEL		
	W10	2452	1	2452	21"x39"	SINGLE CASEMENT-HR		
	W11	3640	5	3640	43"x41"	SINGLE CASEMENT-HR		SOUND DAMPENING GLASS IF POSSIBLE, OR MAYBE LAMINATED GLASS OR EVEN TRIPLE PANE?

SCHEDULES

Windows

CABINET SCHEDULE											
NUMBER	LABEL	QTY	FLOOR	WIDTH	DEPTH	HEIGHT	DESCRIPTION	CODE	MANUFACTURER	COMMENTS	
C01		1	1	27"	12"	84"	UTILITY CABINET				
C02		1	1	30"	3"	84"	UTILITY CABINET				
C03		1	1	38"	30"	14 3/8"	WALL CABINET				
C04		2	1	46"	12"	36"	BASE CABINET				
C05	4DB12	2	1	12"	24"	36"	BASE CABINET				
C06	B12	1	1	12"	24"	36"	BASE CABINET				
C07	B24L	1	1	24"	24"	36"	BASE CABINET				
C08	B24R	7	1	24"	24"	36"	BASE CABINET				
C09	B24	1	1	24"	24"	36"	BASE CABINET				
C10	B30	2	1	30"	24"	36"	BASE CABINET				
C11	B36	1	1	36"	24"	36"	BASE CABINET				
C12	B3614	1	1	36"	14"	36"	BASE CABINET				
C13	BCB1	1	1	1"	24"	36"	BASE CABINET FILLER				
C14	BCB3614	1	1	36"	14"	36"	BASE CABINET				
C15	BF1	1	1	1"	24"	36"	BASE CABINET FILLER				
C16	DCW2436R	1	1	24"	24"	36"	CORNER WALL CABINET				
C17	OTC3624B4	1	1	36"	24"	84"	UTILITY CABINET				
C18	SB24R	1	1	24"	24"	36"	BASE CABINET				
C19	SB27	1	1	27"	24"	36"	BASE CABINET				
C20	SB36	2	1	36"	24"	36"	BASE CABINET				
C21	SB48	1	1	48"	24"	36"	BASE CABINET				
C22	U4824B4	2	1	48"	24"	84"	UTILITY CABINET				
C23	UF124B4	2	1	1"	24"	84"	UTILITY CABINET FILLER				
C24	UF224B4	1	1	2"	24"	84"	UTILITY CABINET FILLER				
C25	W2436L	1	1	24"	12"	36"	WALL CABINET				
C26	W233614L	1	1	23"	14"	36"	WALL CABINET				
C27	W2430L	2	1	24"	12"	30"	WALL CABINET				
C28	W2430R	2	1	24"	12"	30"	WALL CABINET				
C29	W243614R	1	1	24"	14"	36"	WALL CABINET				
C30	W2730	2	1	27"	12"	30"	WALL CABINET				
C31	W3030	3	1	30"	12"	30"	WALL CABINET				
C32	WF130	3	1	1"	12"	30"	WALL CABINET FILLER				
C33	WF230	3	1	2"	12"	30"	WALL CABINET FILLER				
C34	WF23614	1	1	2 3/8"	14"	36"	WALL CABINET FILLER				

Cabinets

703 Eagles Nest Road
Waynesville, NC 28786

DRAWINGS PROVIDED BY:
Dean & Cheryl
Chouinard

DATE:

8/24/20


SCALE:

1/4" = 1'

SHEET:

10

ELECTRICAL

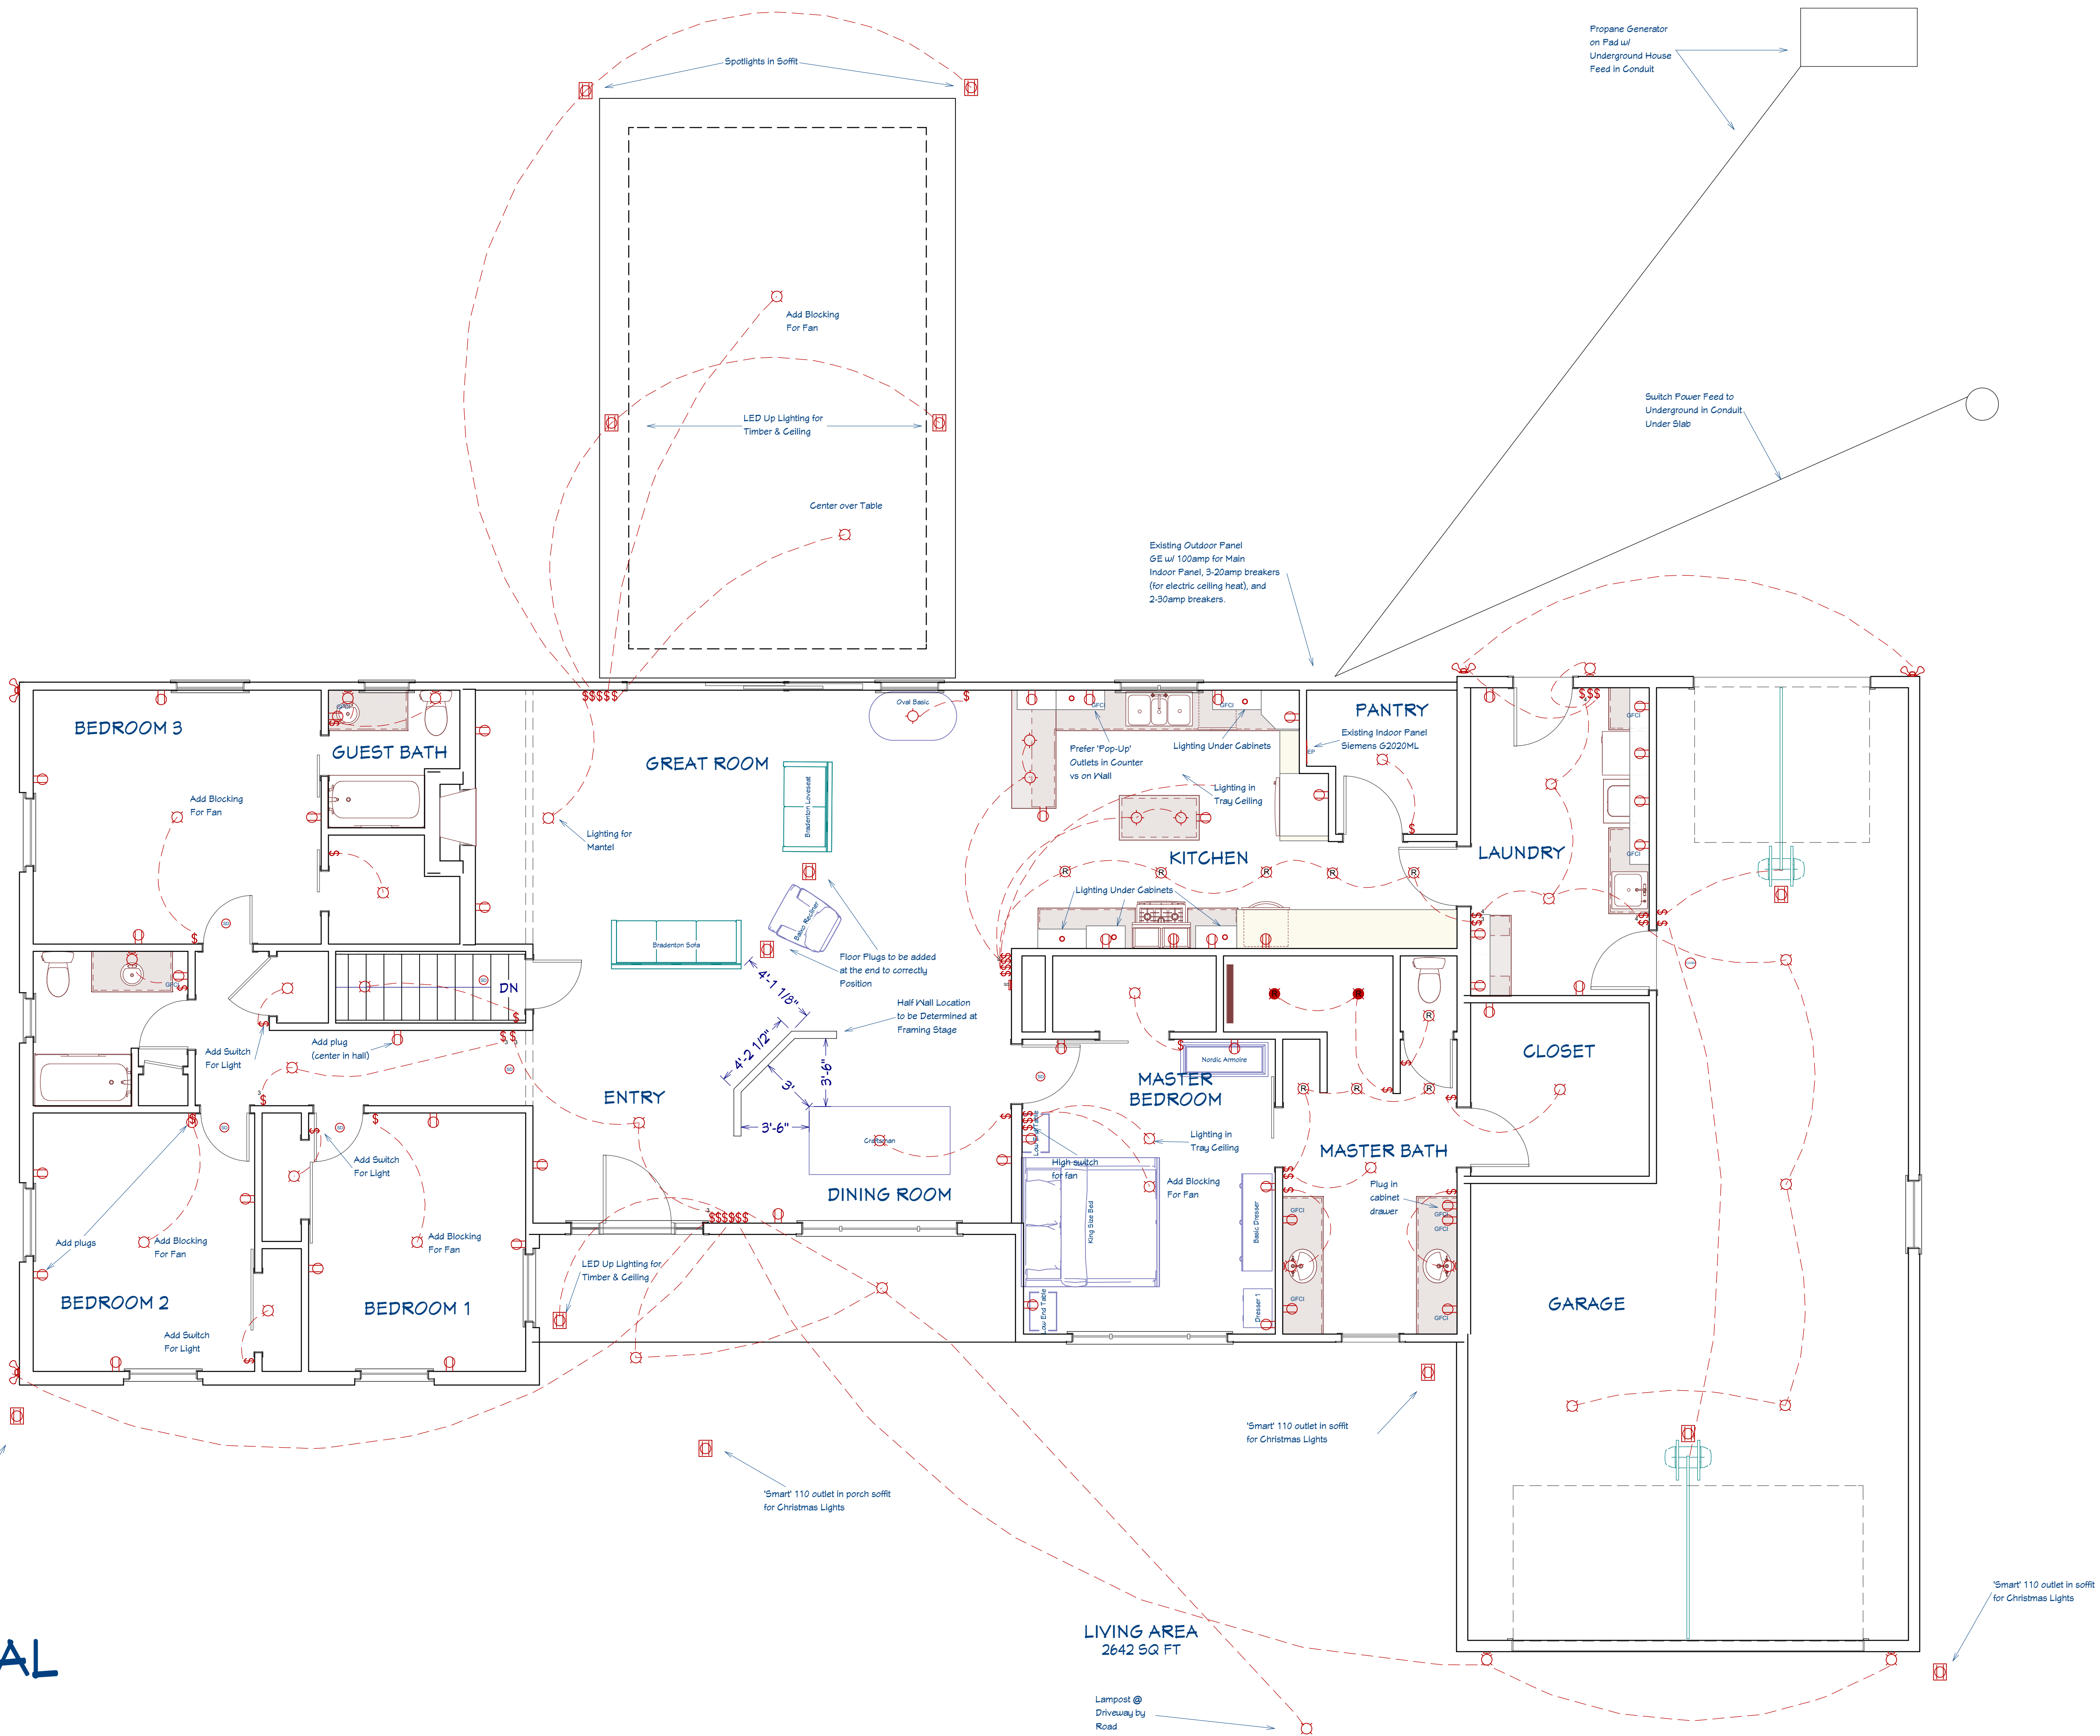

REVISION TABLE

NUMBER	DATE	REVISION BY	DESCRIPTION

703 Eagles Nest Road

Waynesville, NC 28786

DRAWINGS PROVIDED BY:

Dean & Cheryl Chouinard

DATE:

8/24/20

SCALE:

1/4" = 1'

SHEET:

11